




ELEVATION AA
Scale 1/4" = 1'-0"

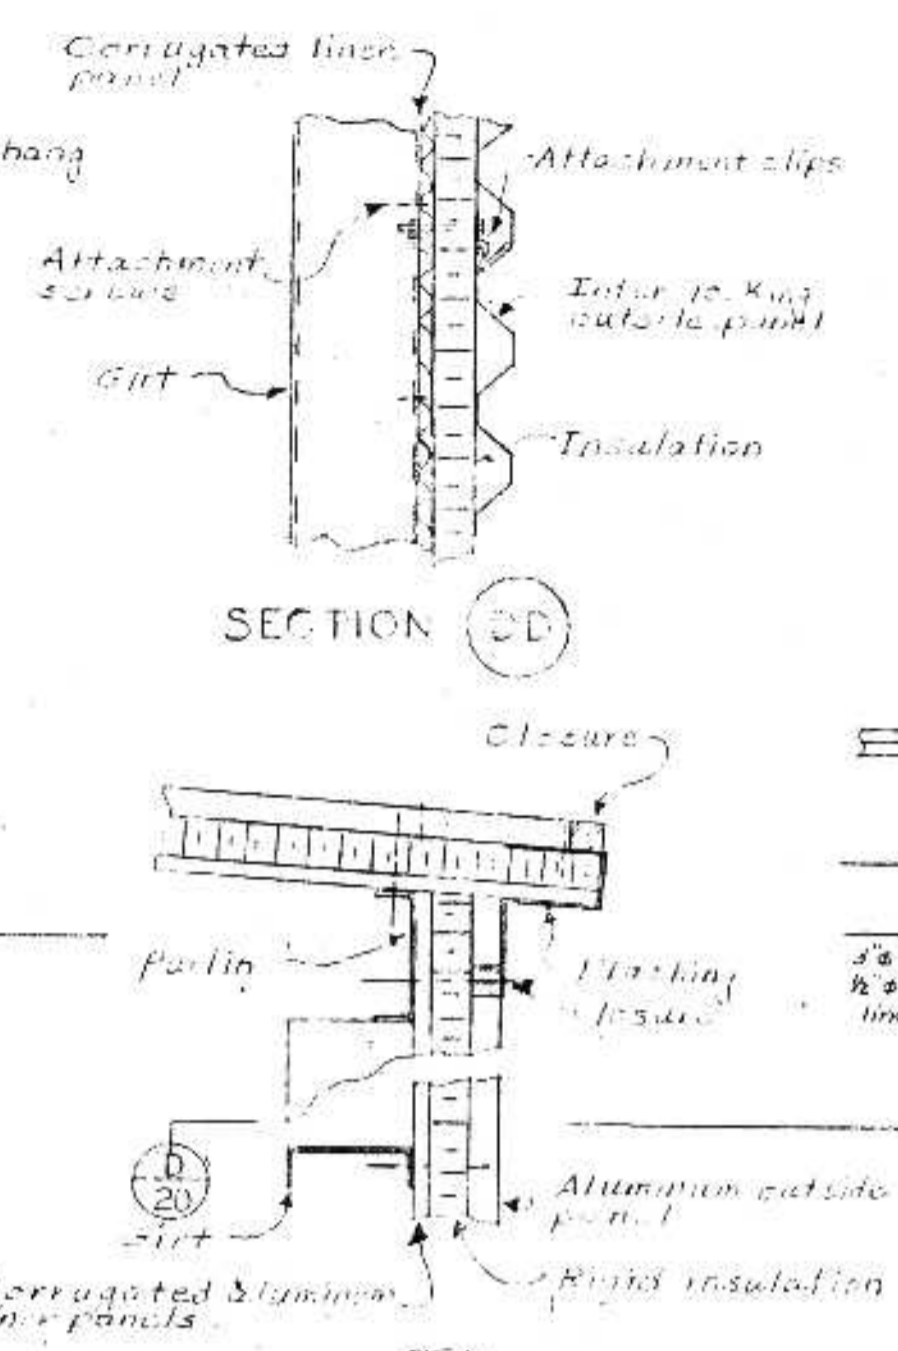


SECTION DD
Scale 1" = 1'-0"

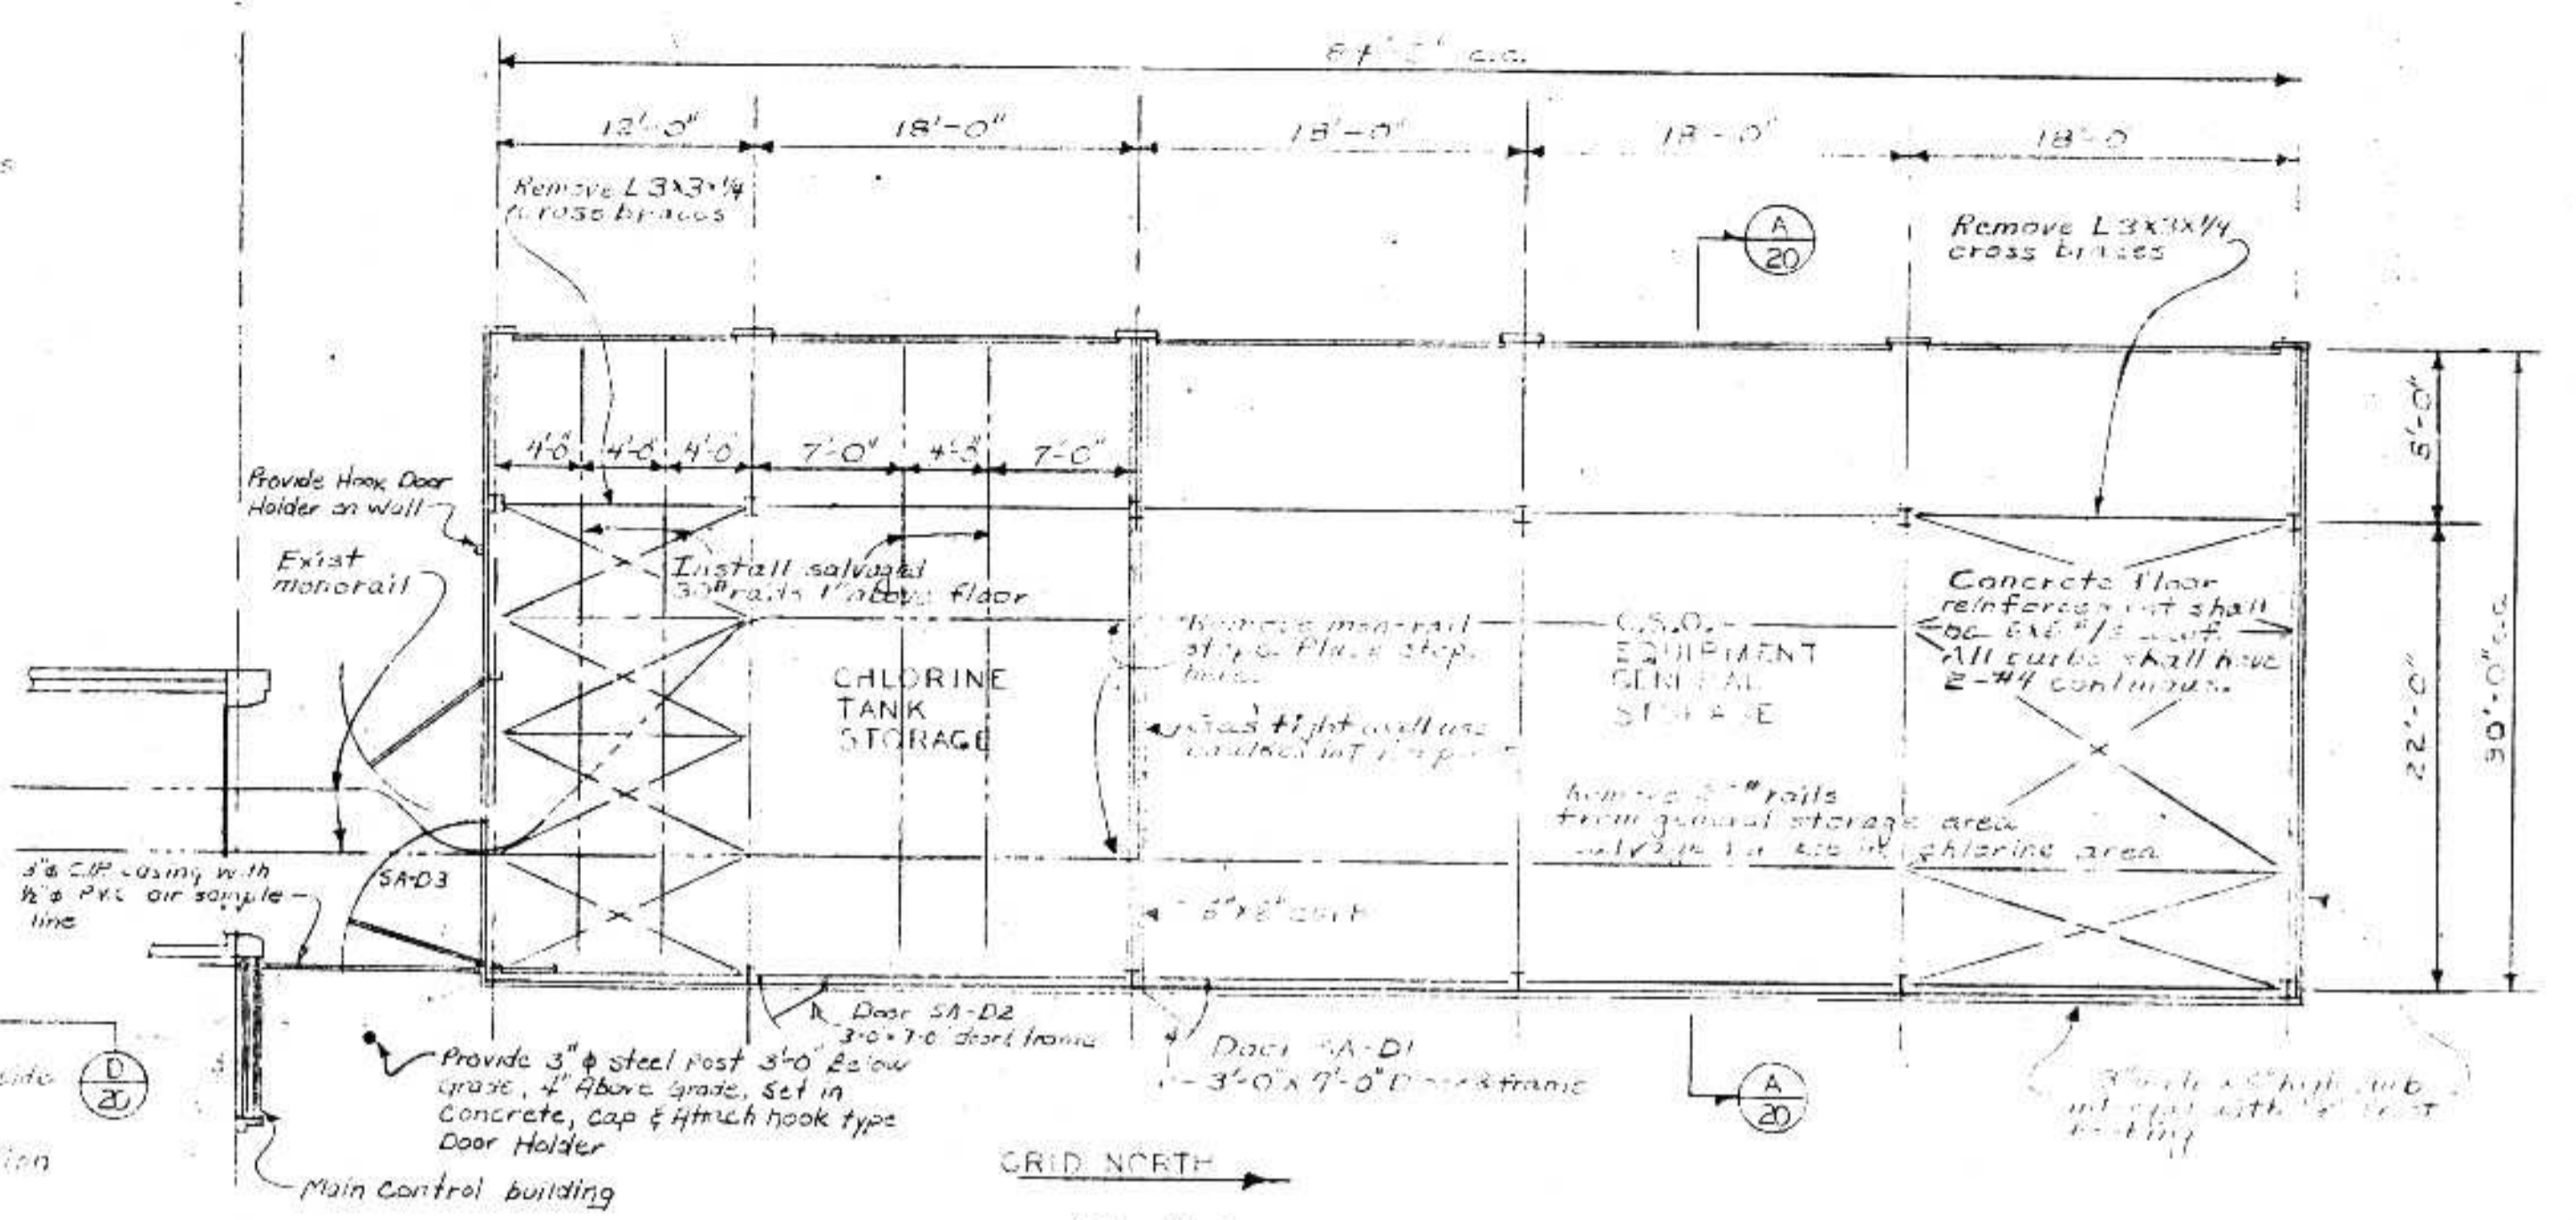


PLAN
Scale 1/8" = 1'-0"

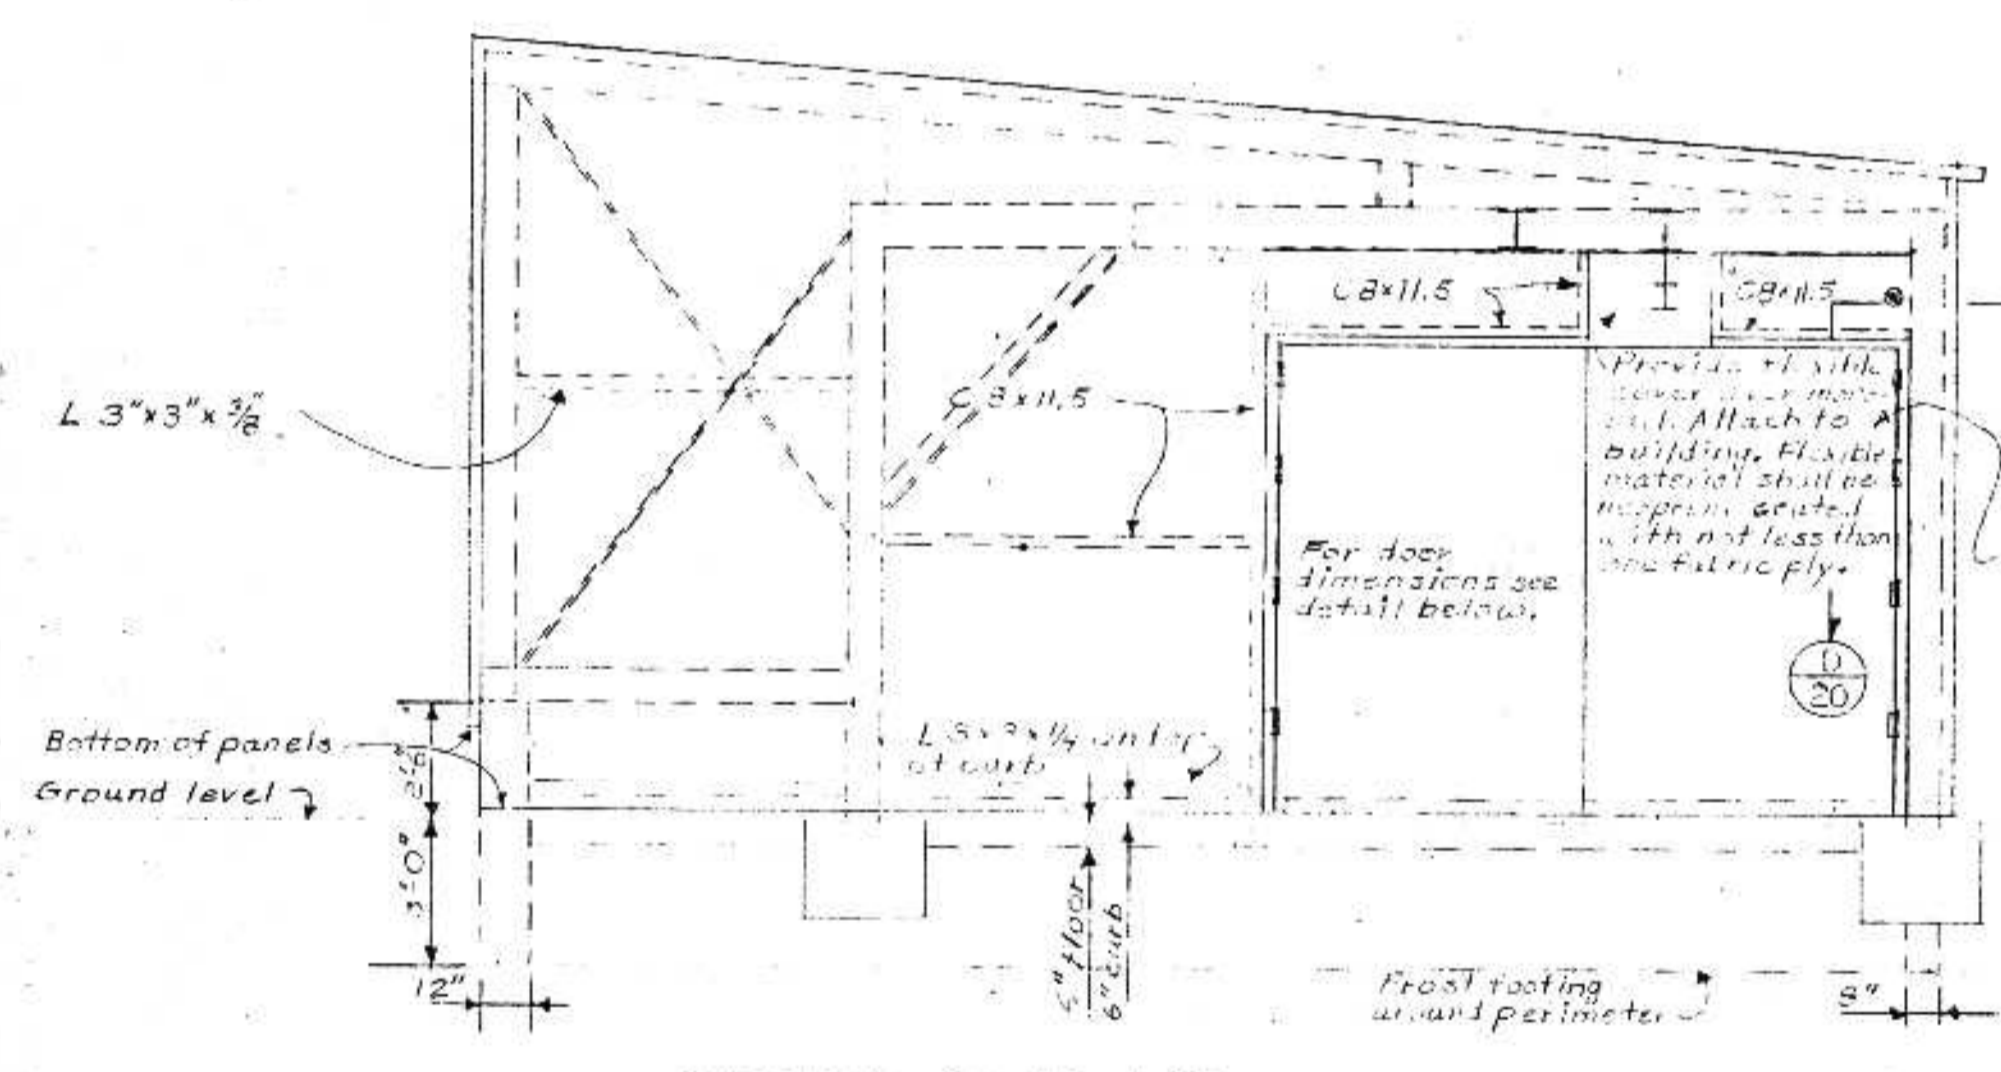


SOUTH ELEVATION
Scale 1/4" = 1'-0"

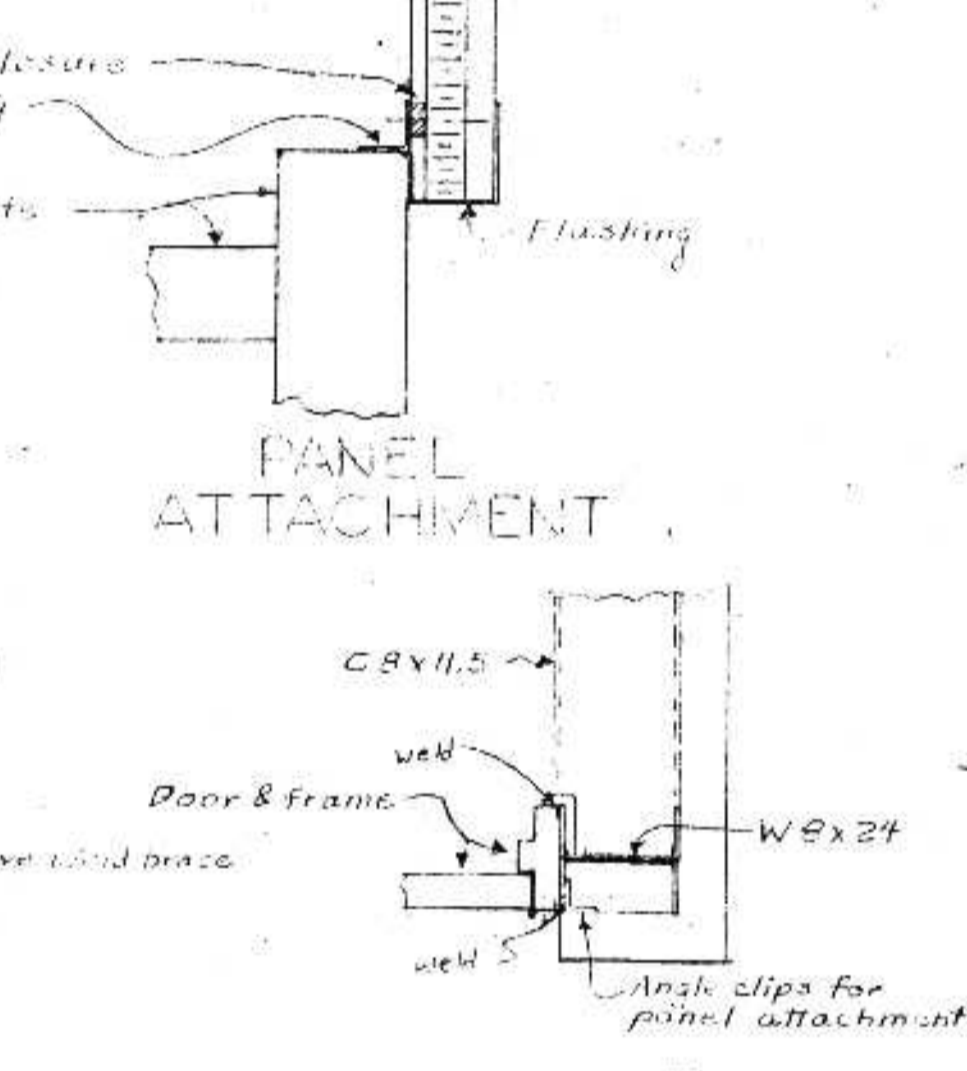

SECTION DD
Scale 1" = 1'-0"

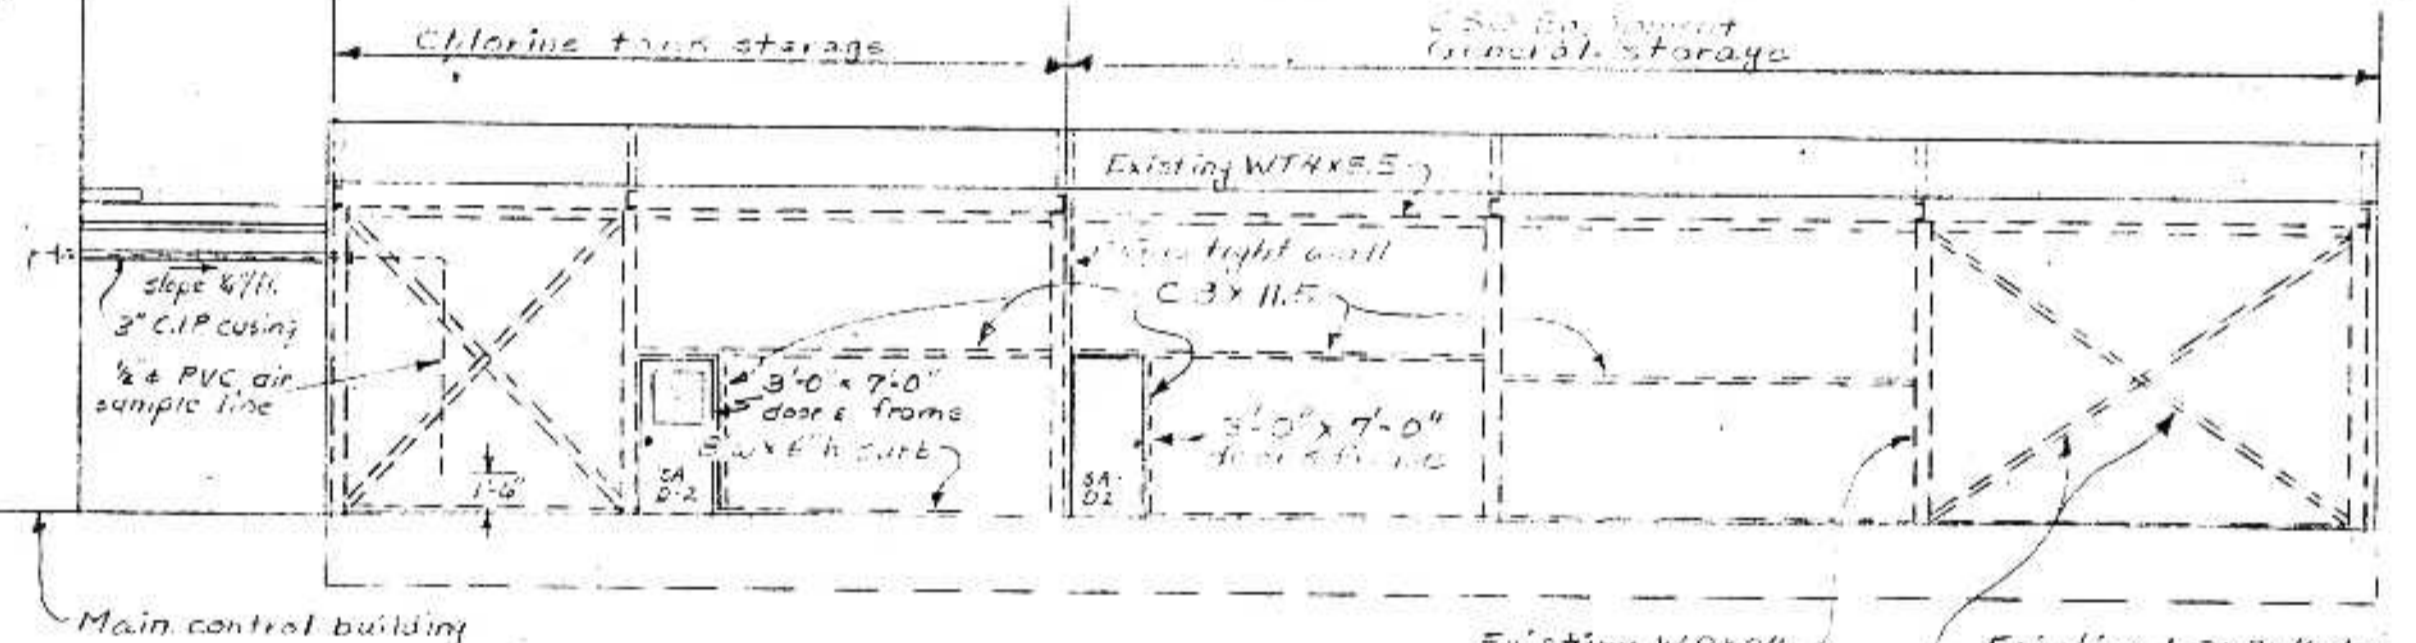


EAST ELEVATION
Scale 1/8" = 1'-0"

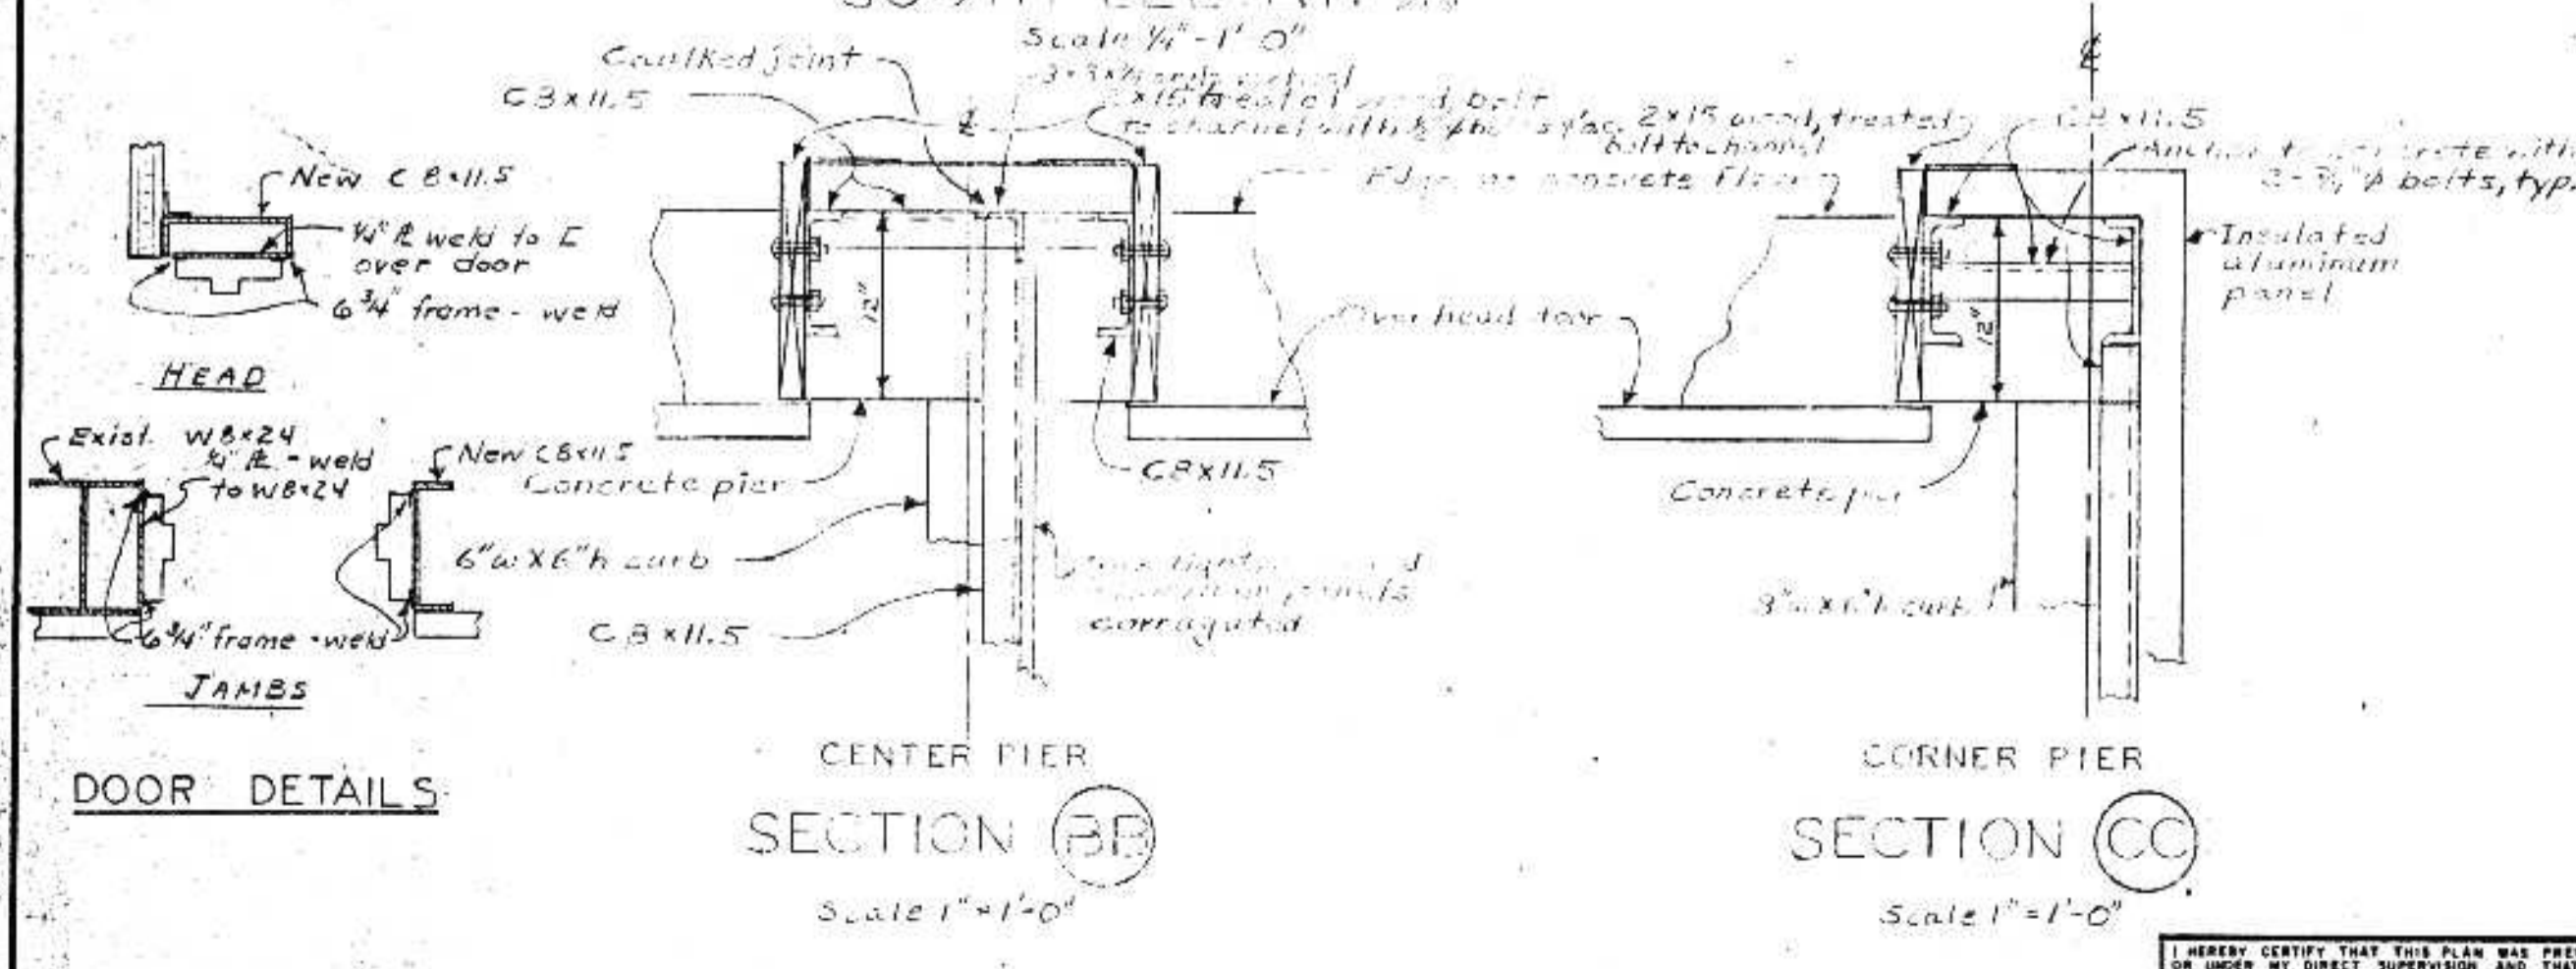


DOOR DETAILS

SECTION BB
Scale 1" = 1'-0"

SECTION CC
Scale 1" = 1'-0"

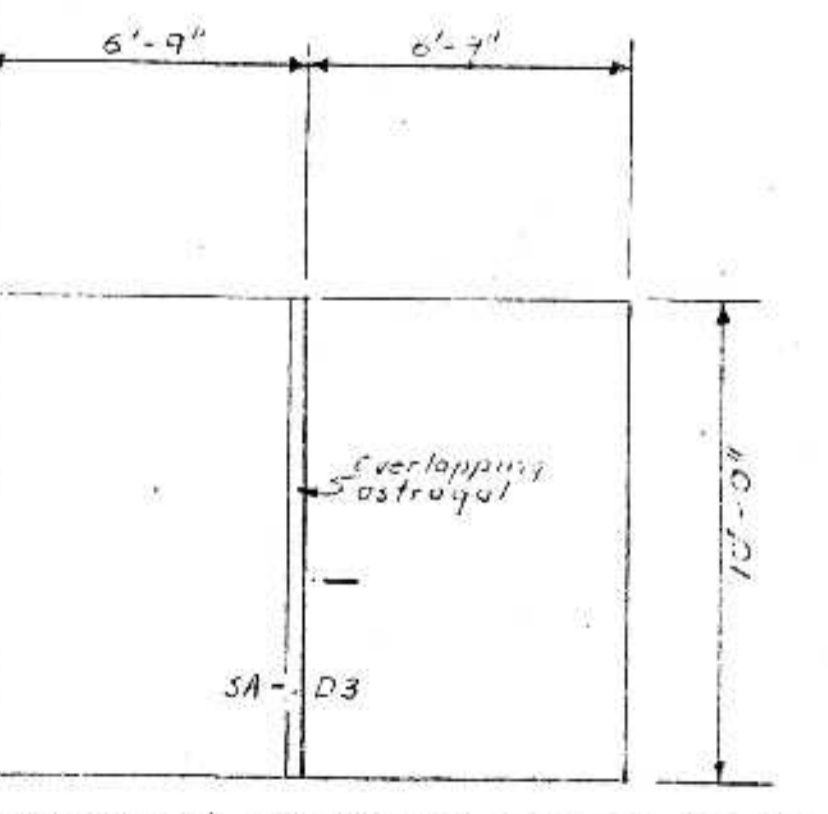


CHLORINE STORAGE SOUTH DOOR
Scale 1/4" = 1'-0"

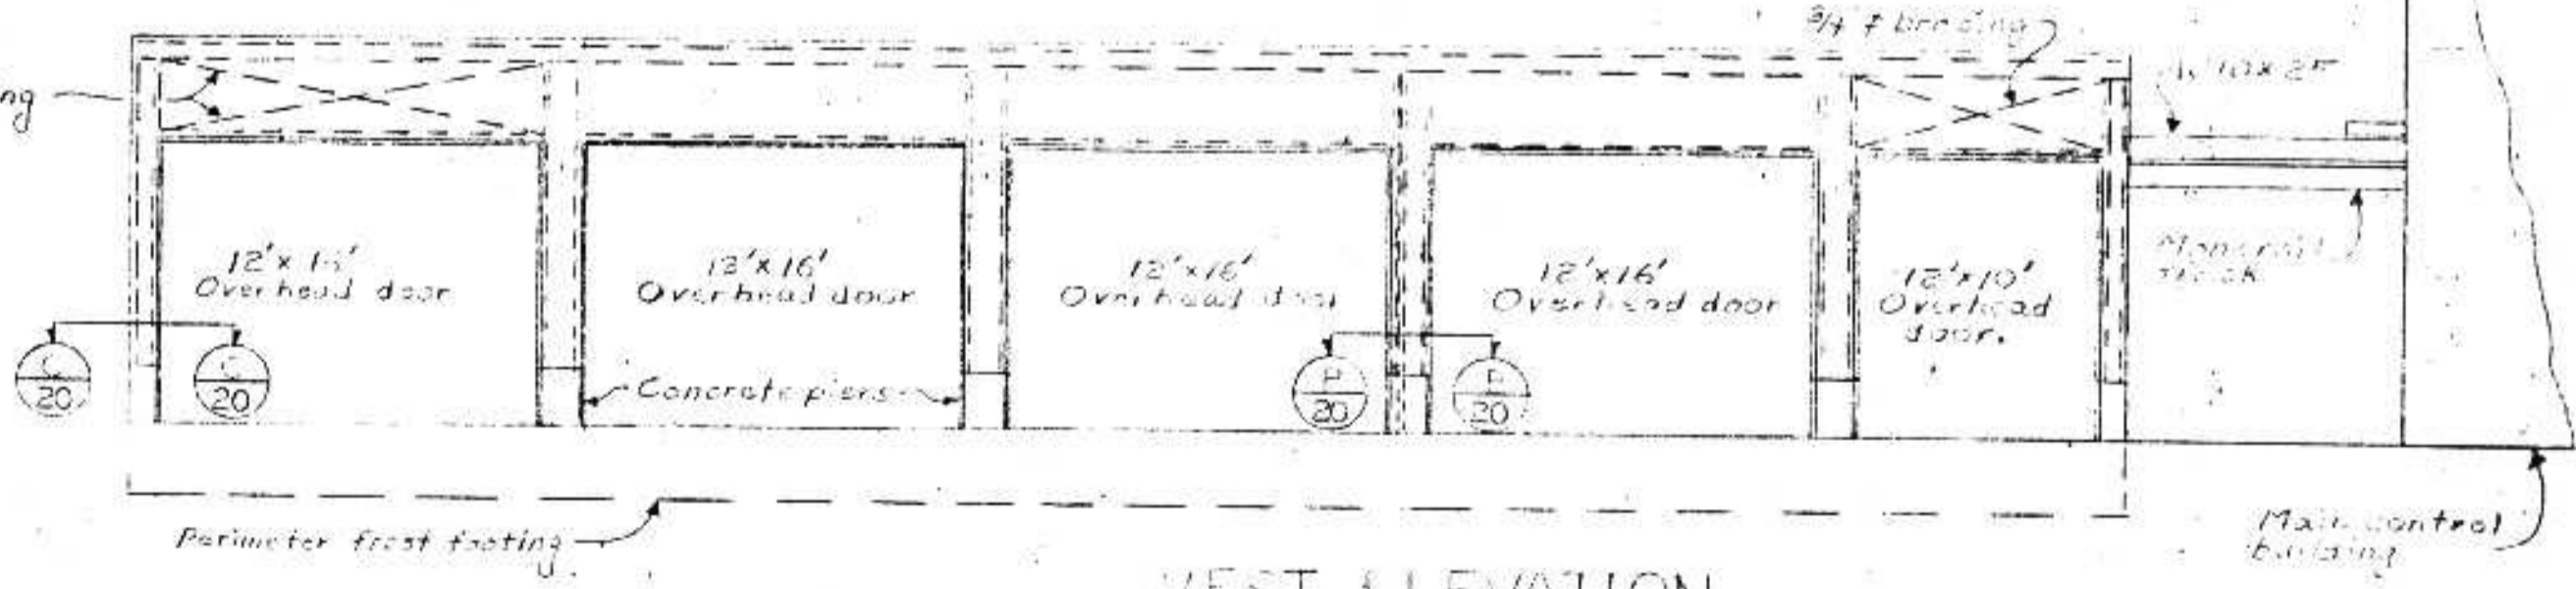


WEST ELEVATION
Scale 1/8" = 1'-0"

- NOTES:
- Existing structure consists of six (6) bents to support monorail. Contractor shall enlarge structure to meet, provide slope, roof, enclosure walls and provide concrete footings, curb and floor as shown and described in specifications.
 - All structural steel connections shall be field welded all around.
 - Contractor shall verify all dimensions to curb fabrications.
 - Gen. Contractor shall provide steel framing around all ventilation openings - See Mechanical Drawings.
 - Gas-tight wall shall be provided between chlorine tank storage area and general storage area, and contractor shall submit drawings and details of construction for approval prior to fabrication.

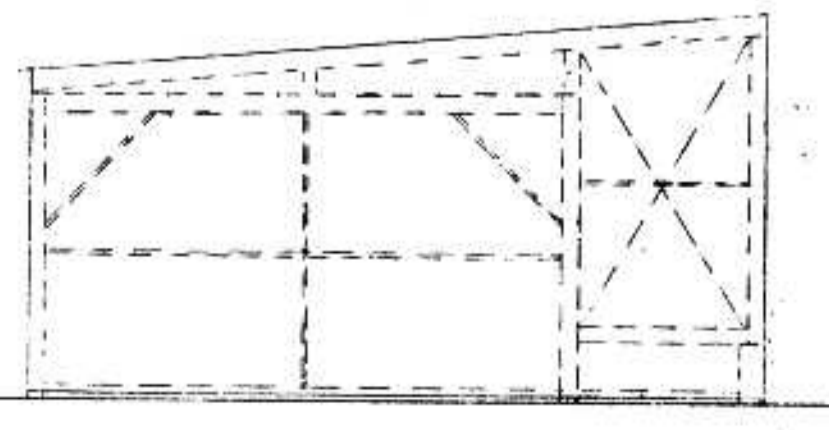


NORTH ELEVATION
Scale 1/8" = 1'-0"

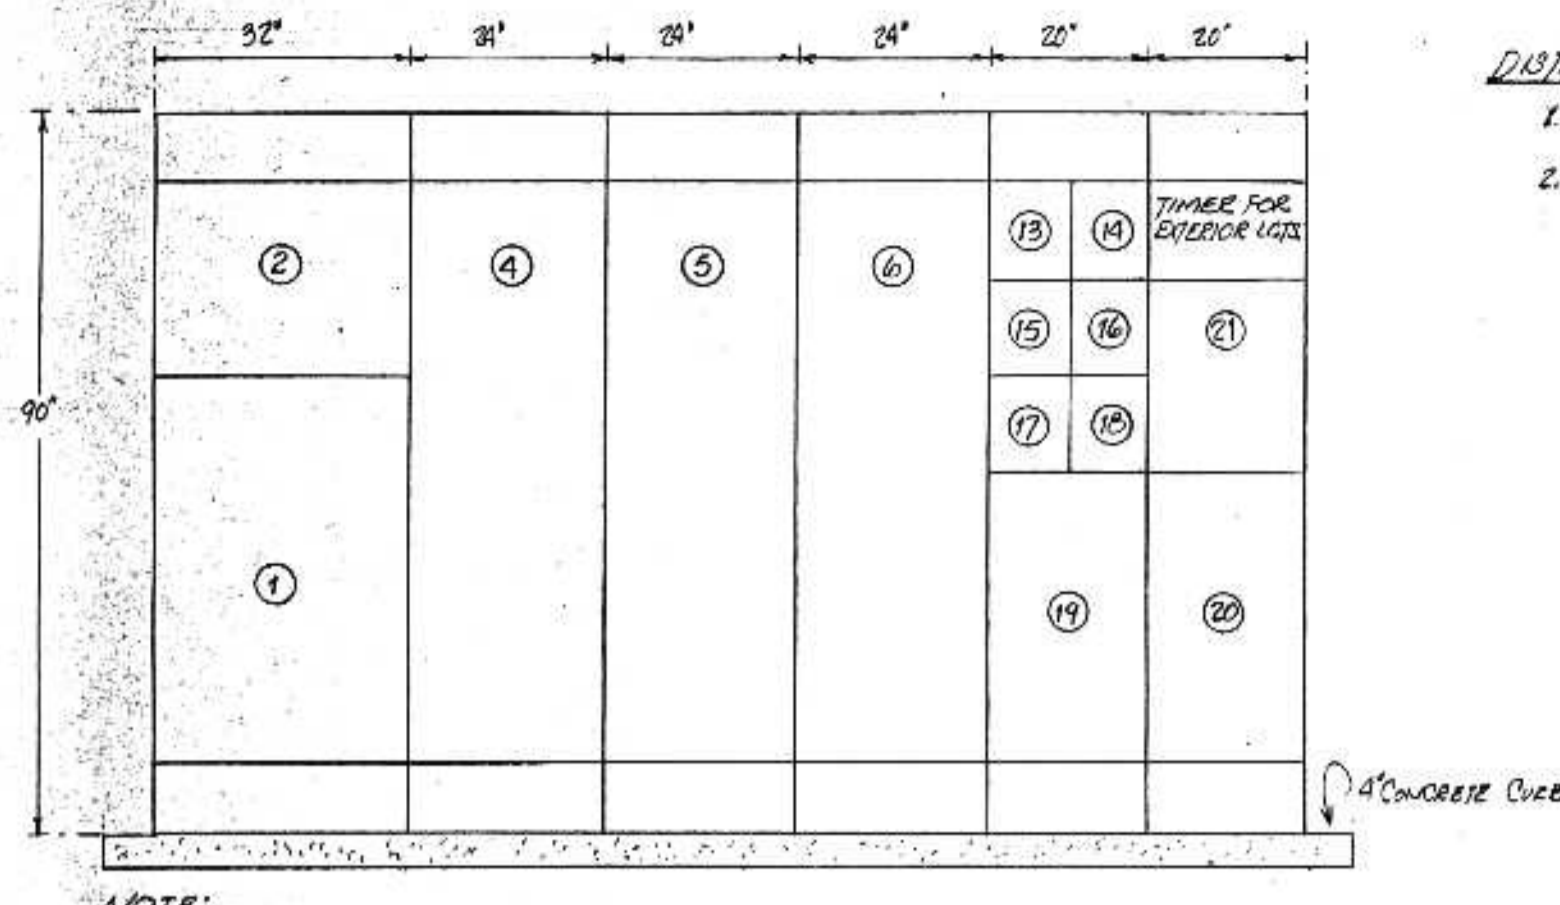


NOTE:

SOUTH ELEVATION - DISTRIBUTION AND CONTROL CENTER NO. 4
SCALE: 1/2" = 1'-0"

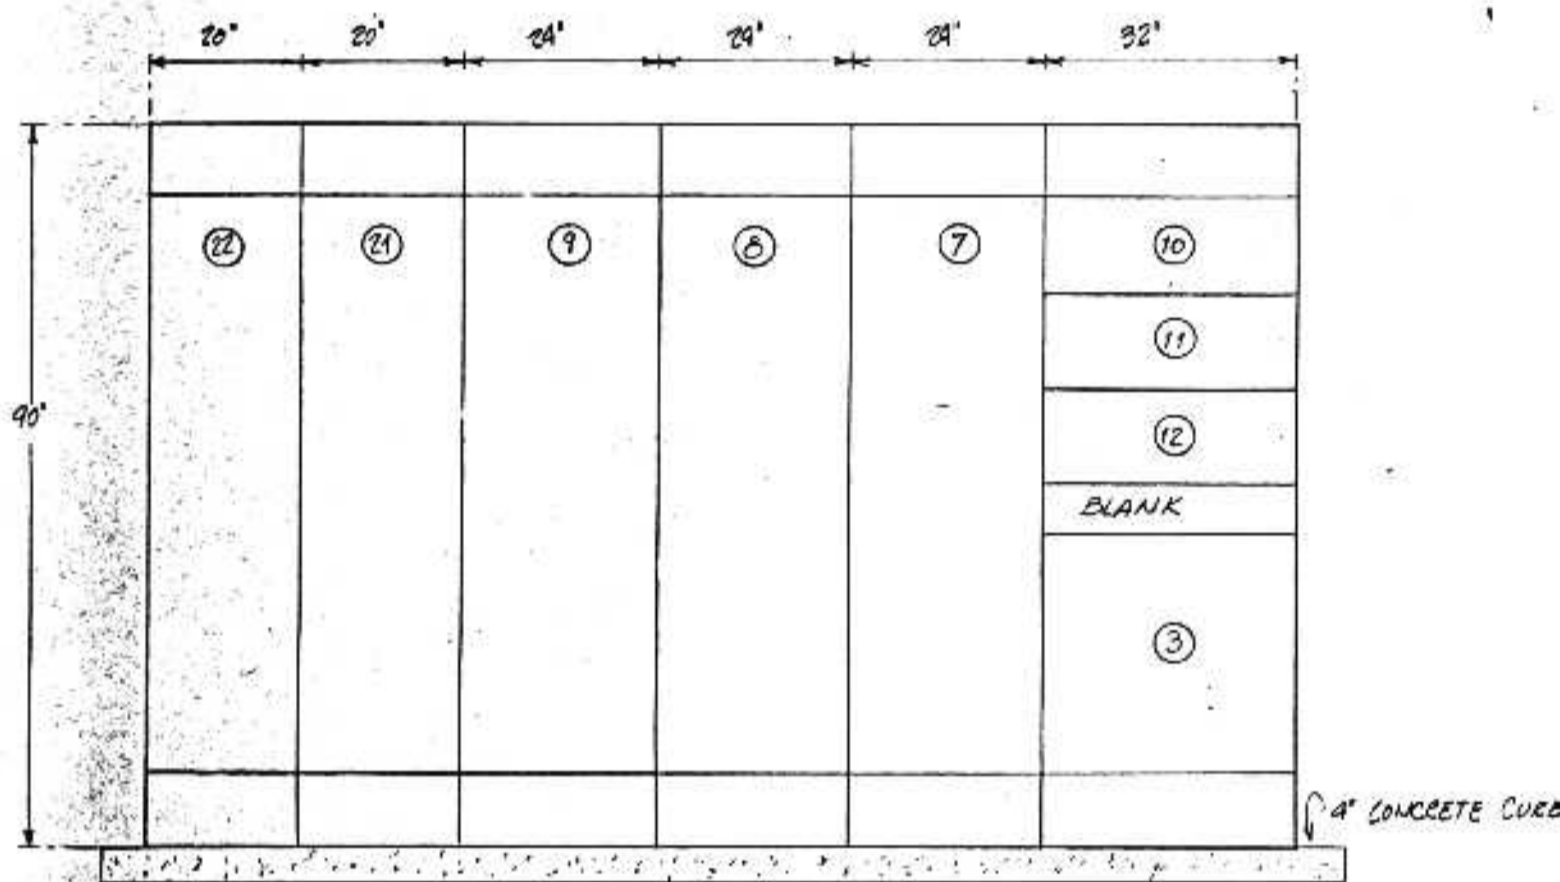


NORTH ELEVATION - DISTRIBUTION AND CONTROL CENTER NO. 4
SCALE: 1/2" = 1'-0"

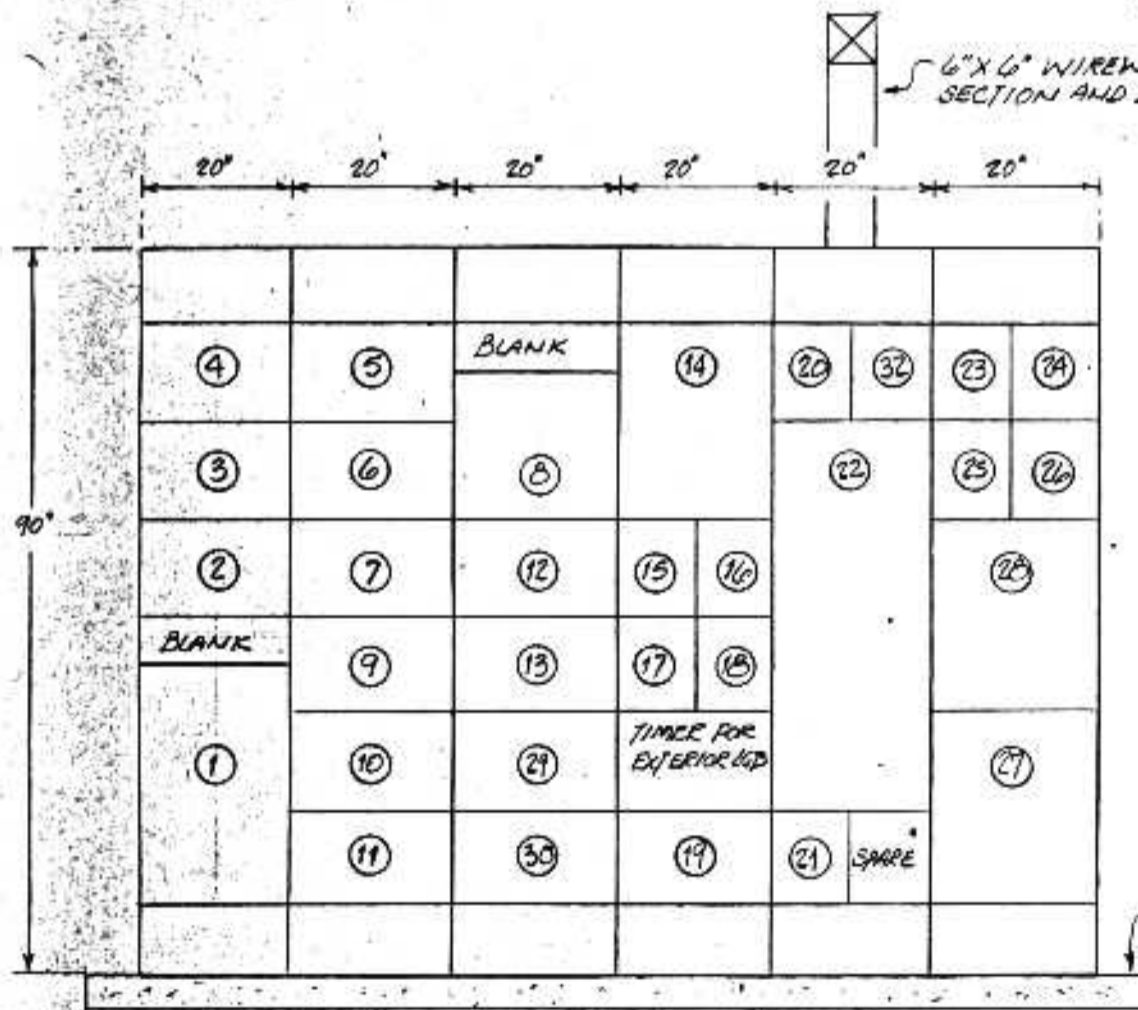



DISTRIBUTION AND CONTROL CENTER NO. 5
SCALE: 1/2" = 1'-0"

DISTRIBUTION AND CONTROL CENTER #4 & 5 NOTES:


- 1. REFER TO DISTRIBUTION CONTROL CENTER SCHEDULE FOR EQUIPMENT INDICATED BY ENCIRCLED NUMBERS.
- 2. ARRANGEMENT SHOWN IS TYPICAL AND MAY VARY IN LOCATION AND DIMENSIONS AS REQUIRED BY FIELD WITH ENGINEER'S APPROVAL. IF MORE EQUIPMENT SPECIFIED THE MFG. SHALL PROVIDE REQUIRED DIMENSIONS.

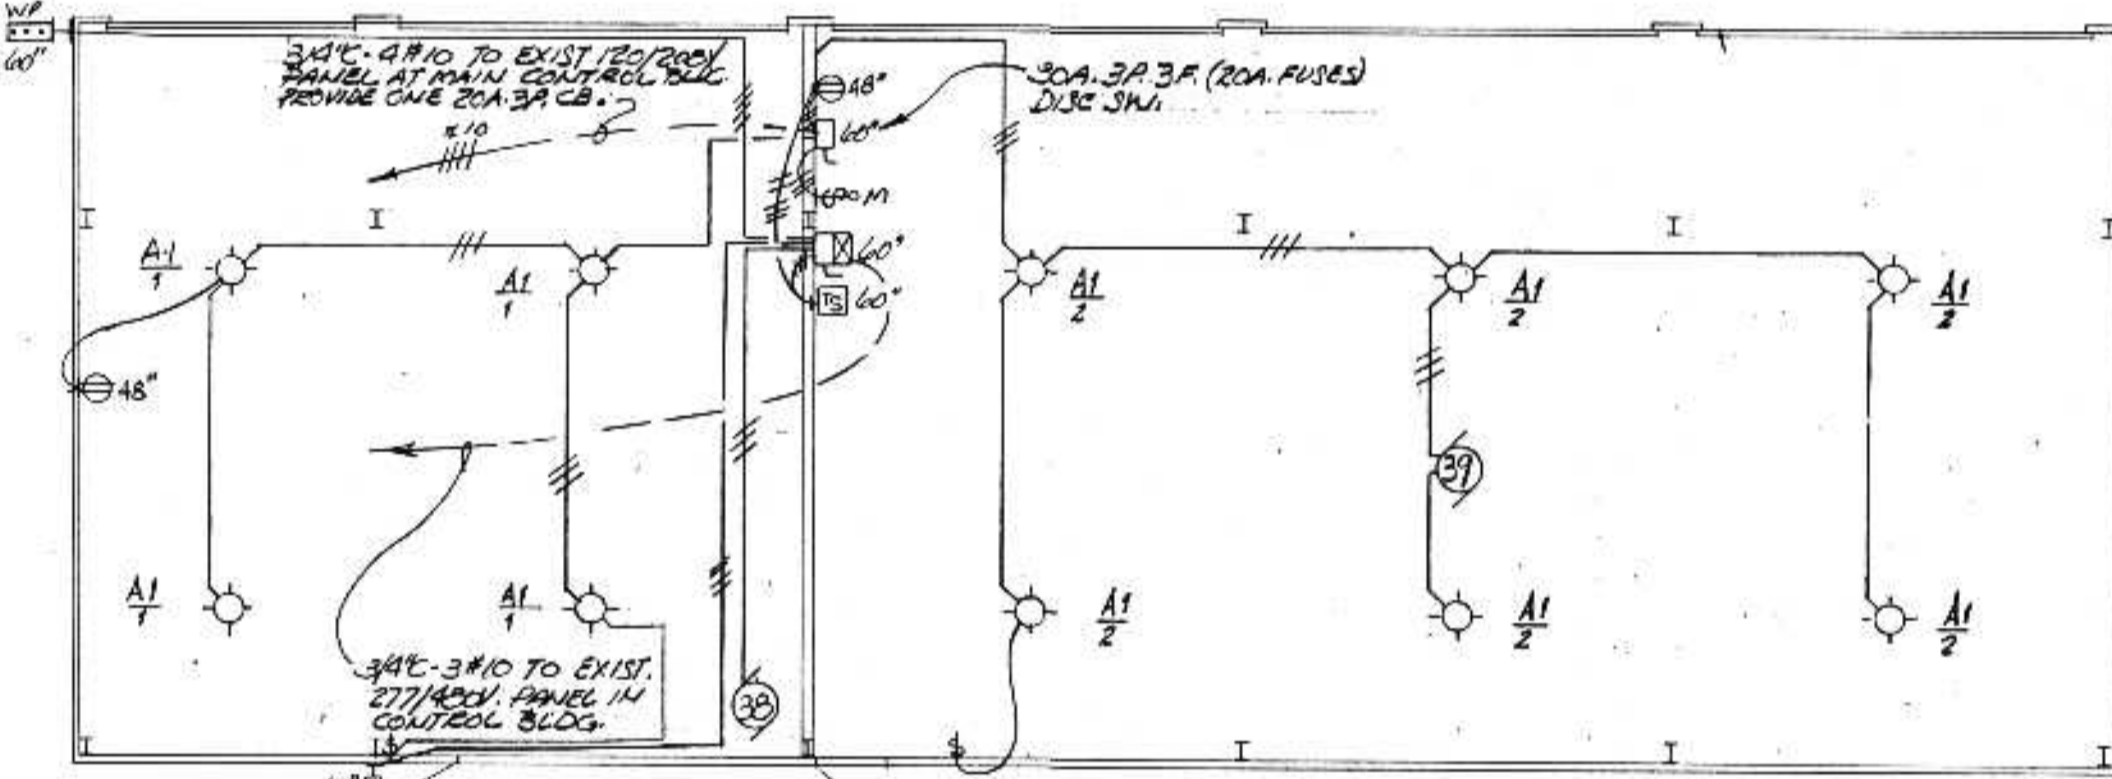

CHLORINE AND GARAGE BUILDING
SCALE: 1/8" = 1'-0"

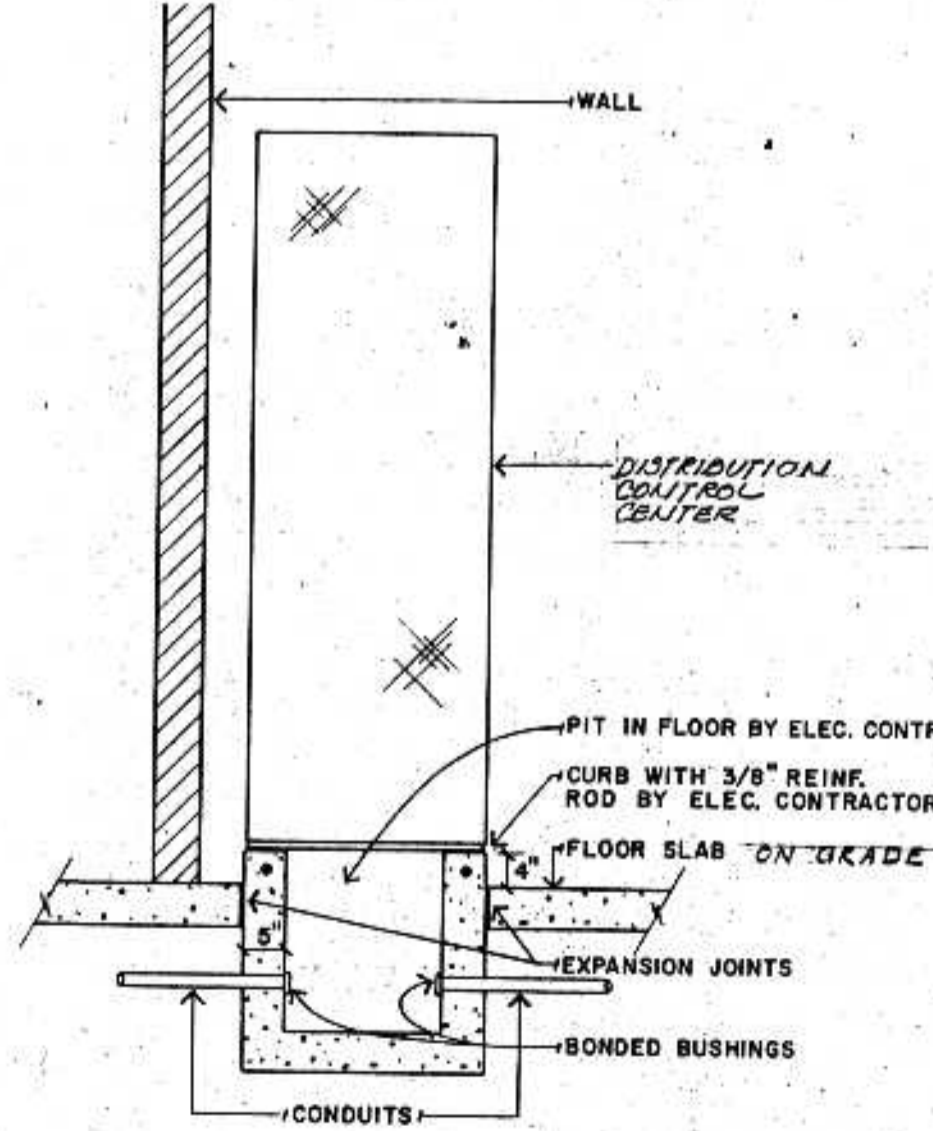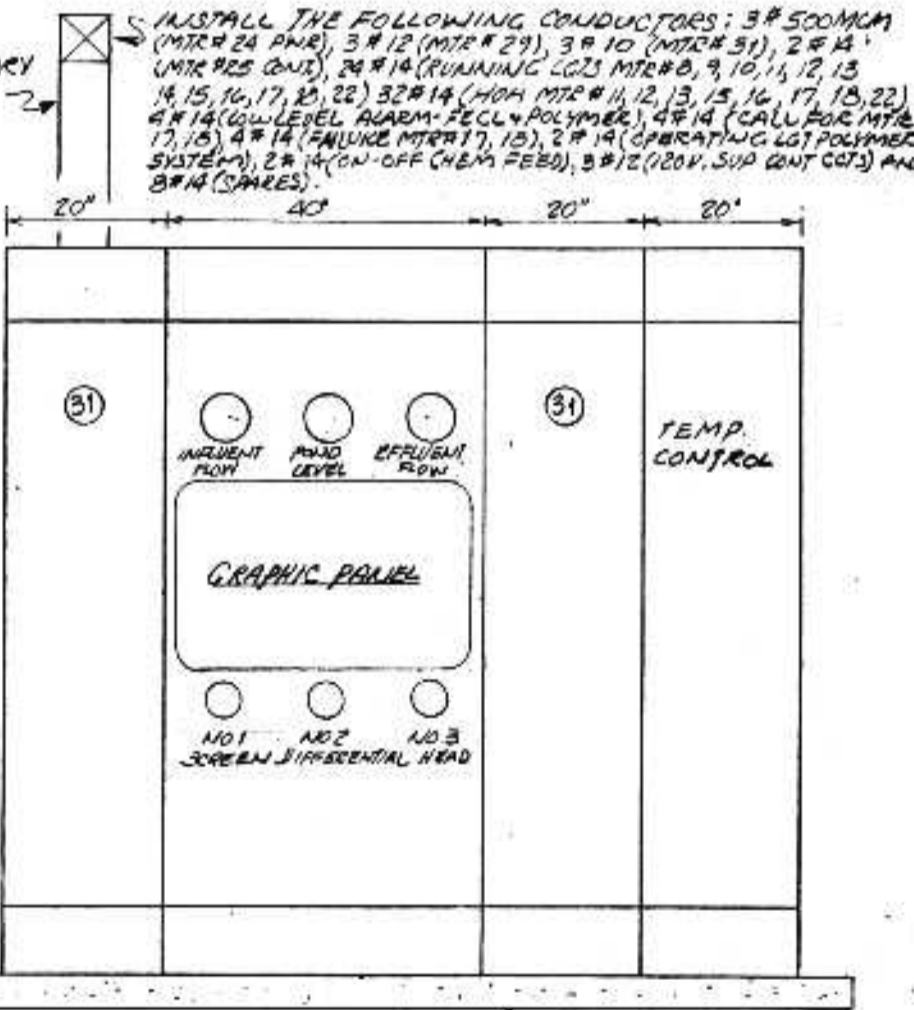

DISTRIBUTION CONTROL CENTER NO. 4

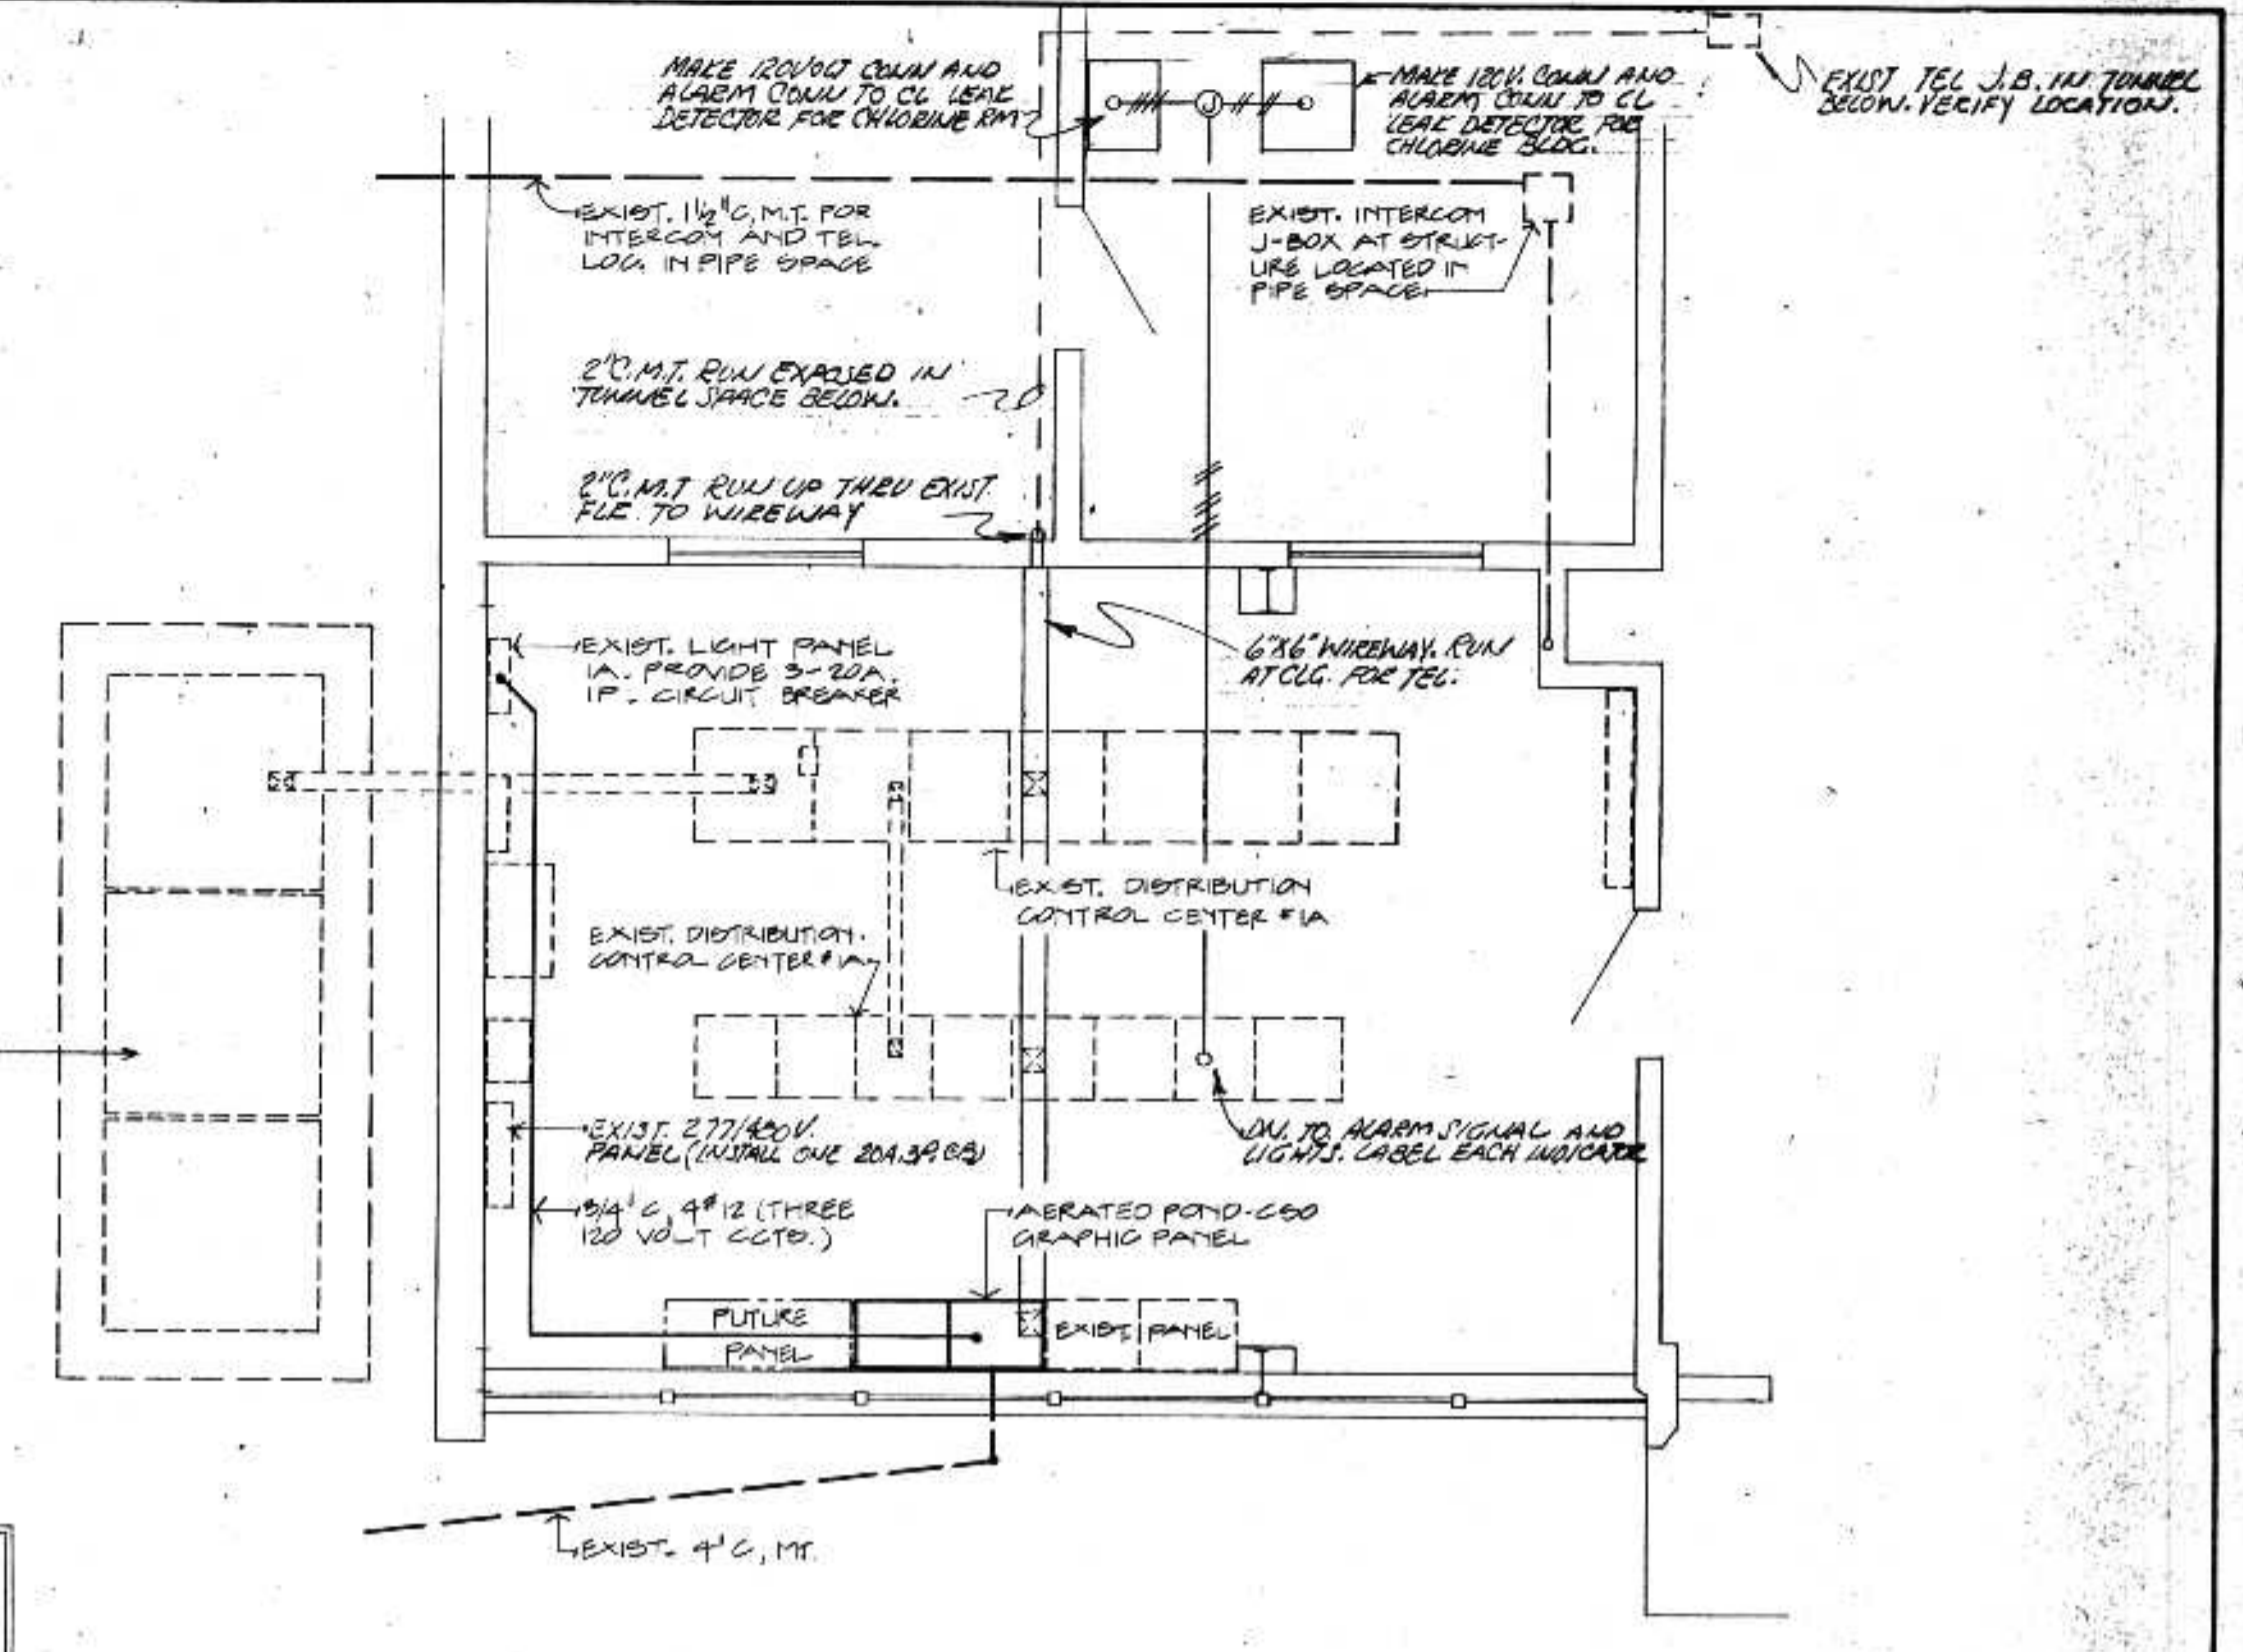

GRAPHIC PANEL LOCATION CONTROL BLDG. MAIN PLANT
SCALE: 1/4" = 1'-0"

ERICKSEN ELLISON AND ASSOCIATES INC.
CONSULTING ENGINEERS
SAINT PAUL, MINNESOTA

I HEREBY CERTIFY THAT THIS PLAN WAS PREPARED BY ME OR UNDER MY DIRECT SUPERVISION AND THAT I AM A REGISTERED PROFESSIONAL ENGINEER UNDER THE LAWS OF THE STATE OF WISCONSIN.
DATE: JUNE 14, 1975. REG. NO. E-14569. *Jim Thihaule*

SURVEY: _____
DRAWING: _____
DESIGN: _____
APPROVED: RET



REVISIONS:
NO. DATE DESCRIPTION
1 6/15/75 Add C.C. Cabling & Tel. wire
2 6/17/75

BONESTROO, ROSENE, ANDERLIK & ASSOC., INC.
ST. PAUL, MINNESOTA

SUPERIOR, WISCONSIN
DATE: JUNE 14, 1975 COMM 6888 F

DNR OCT 10 1975

C.S.O. STORAGE ELECTRICAL & D.C.C.'S

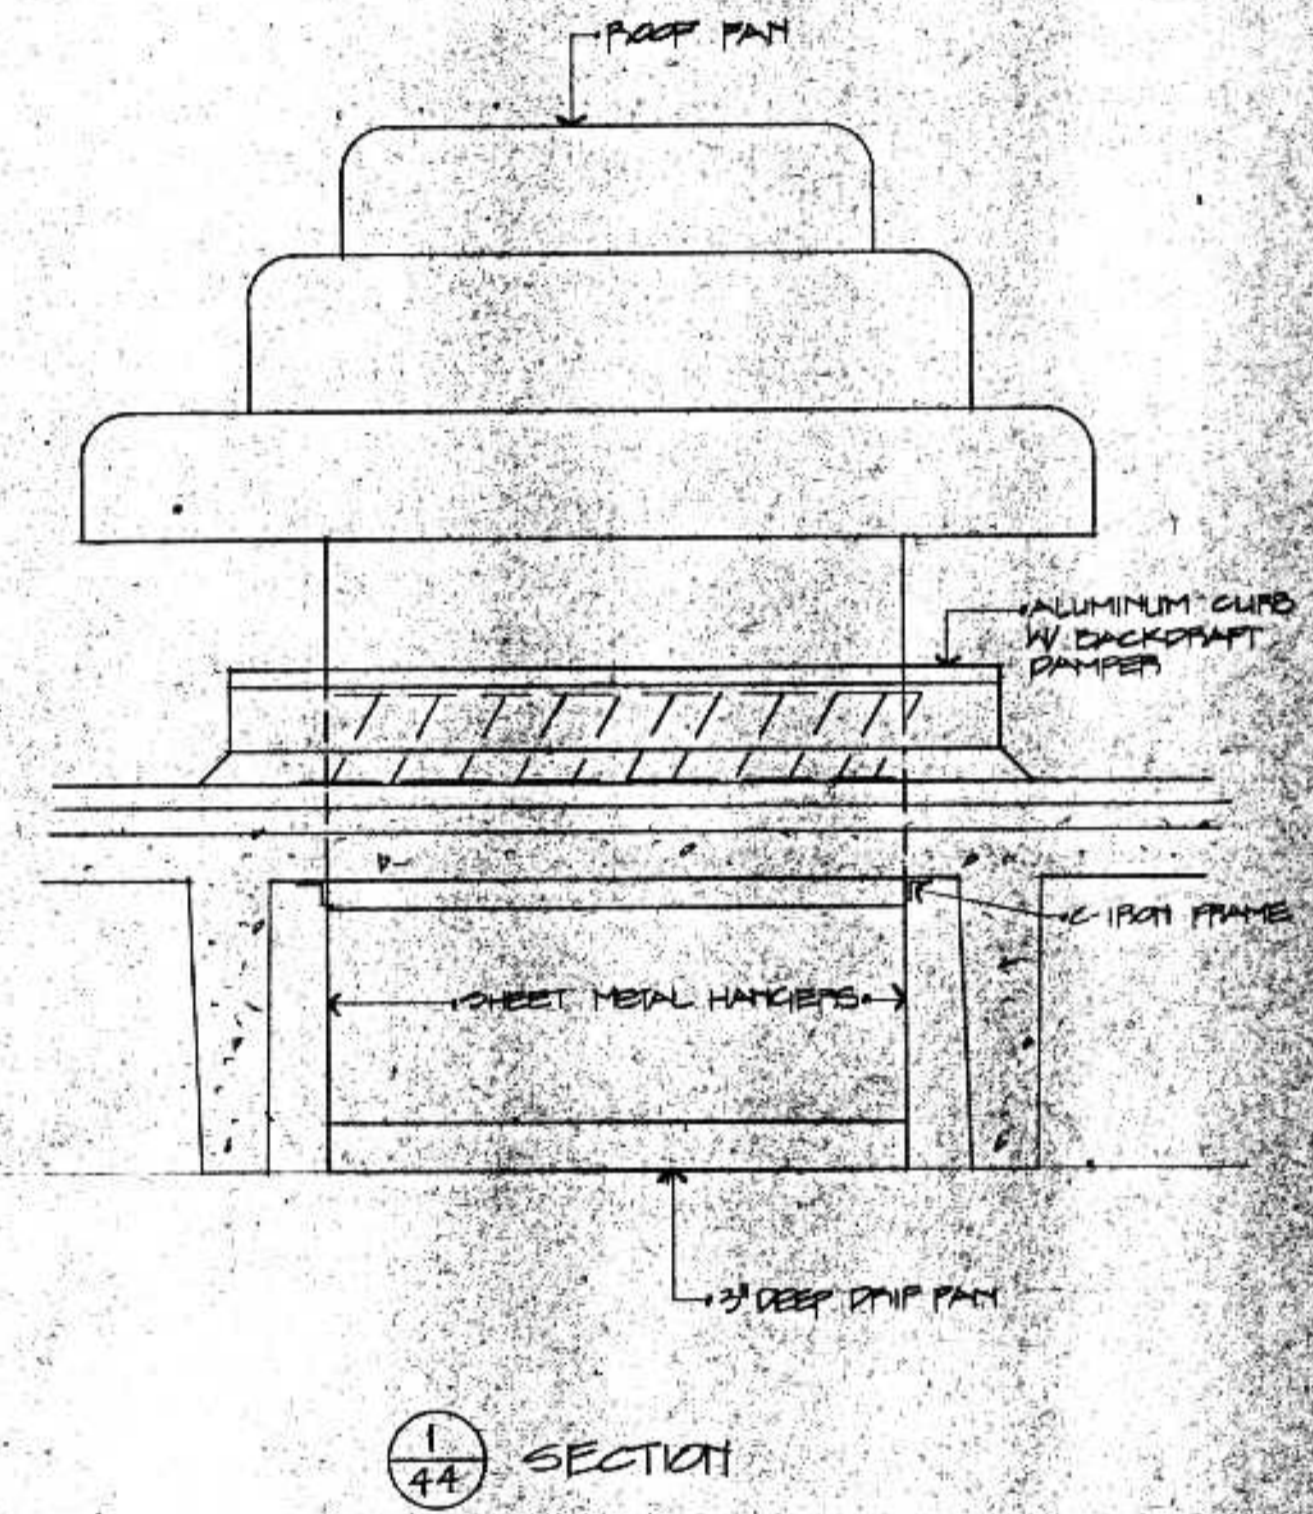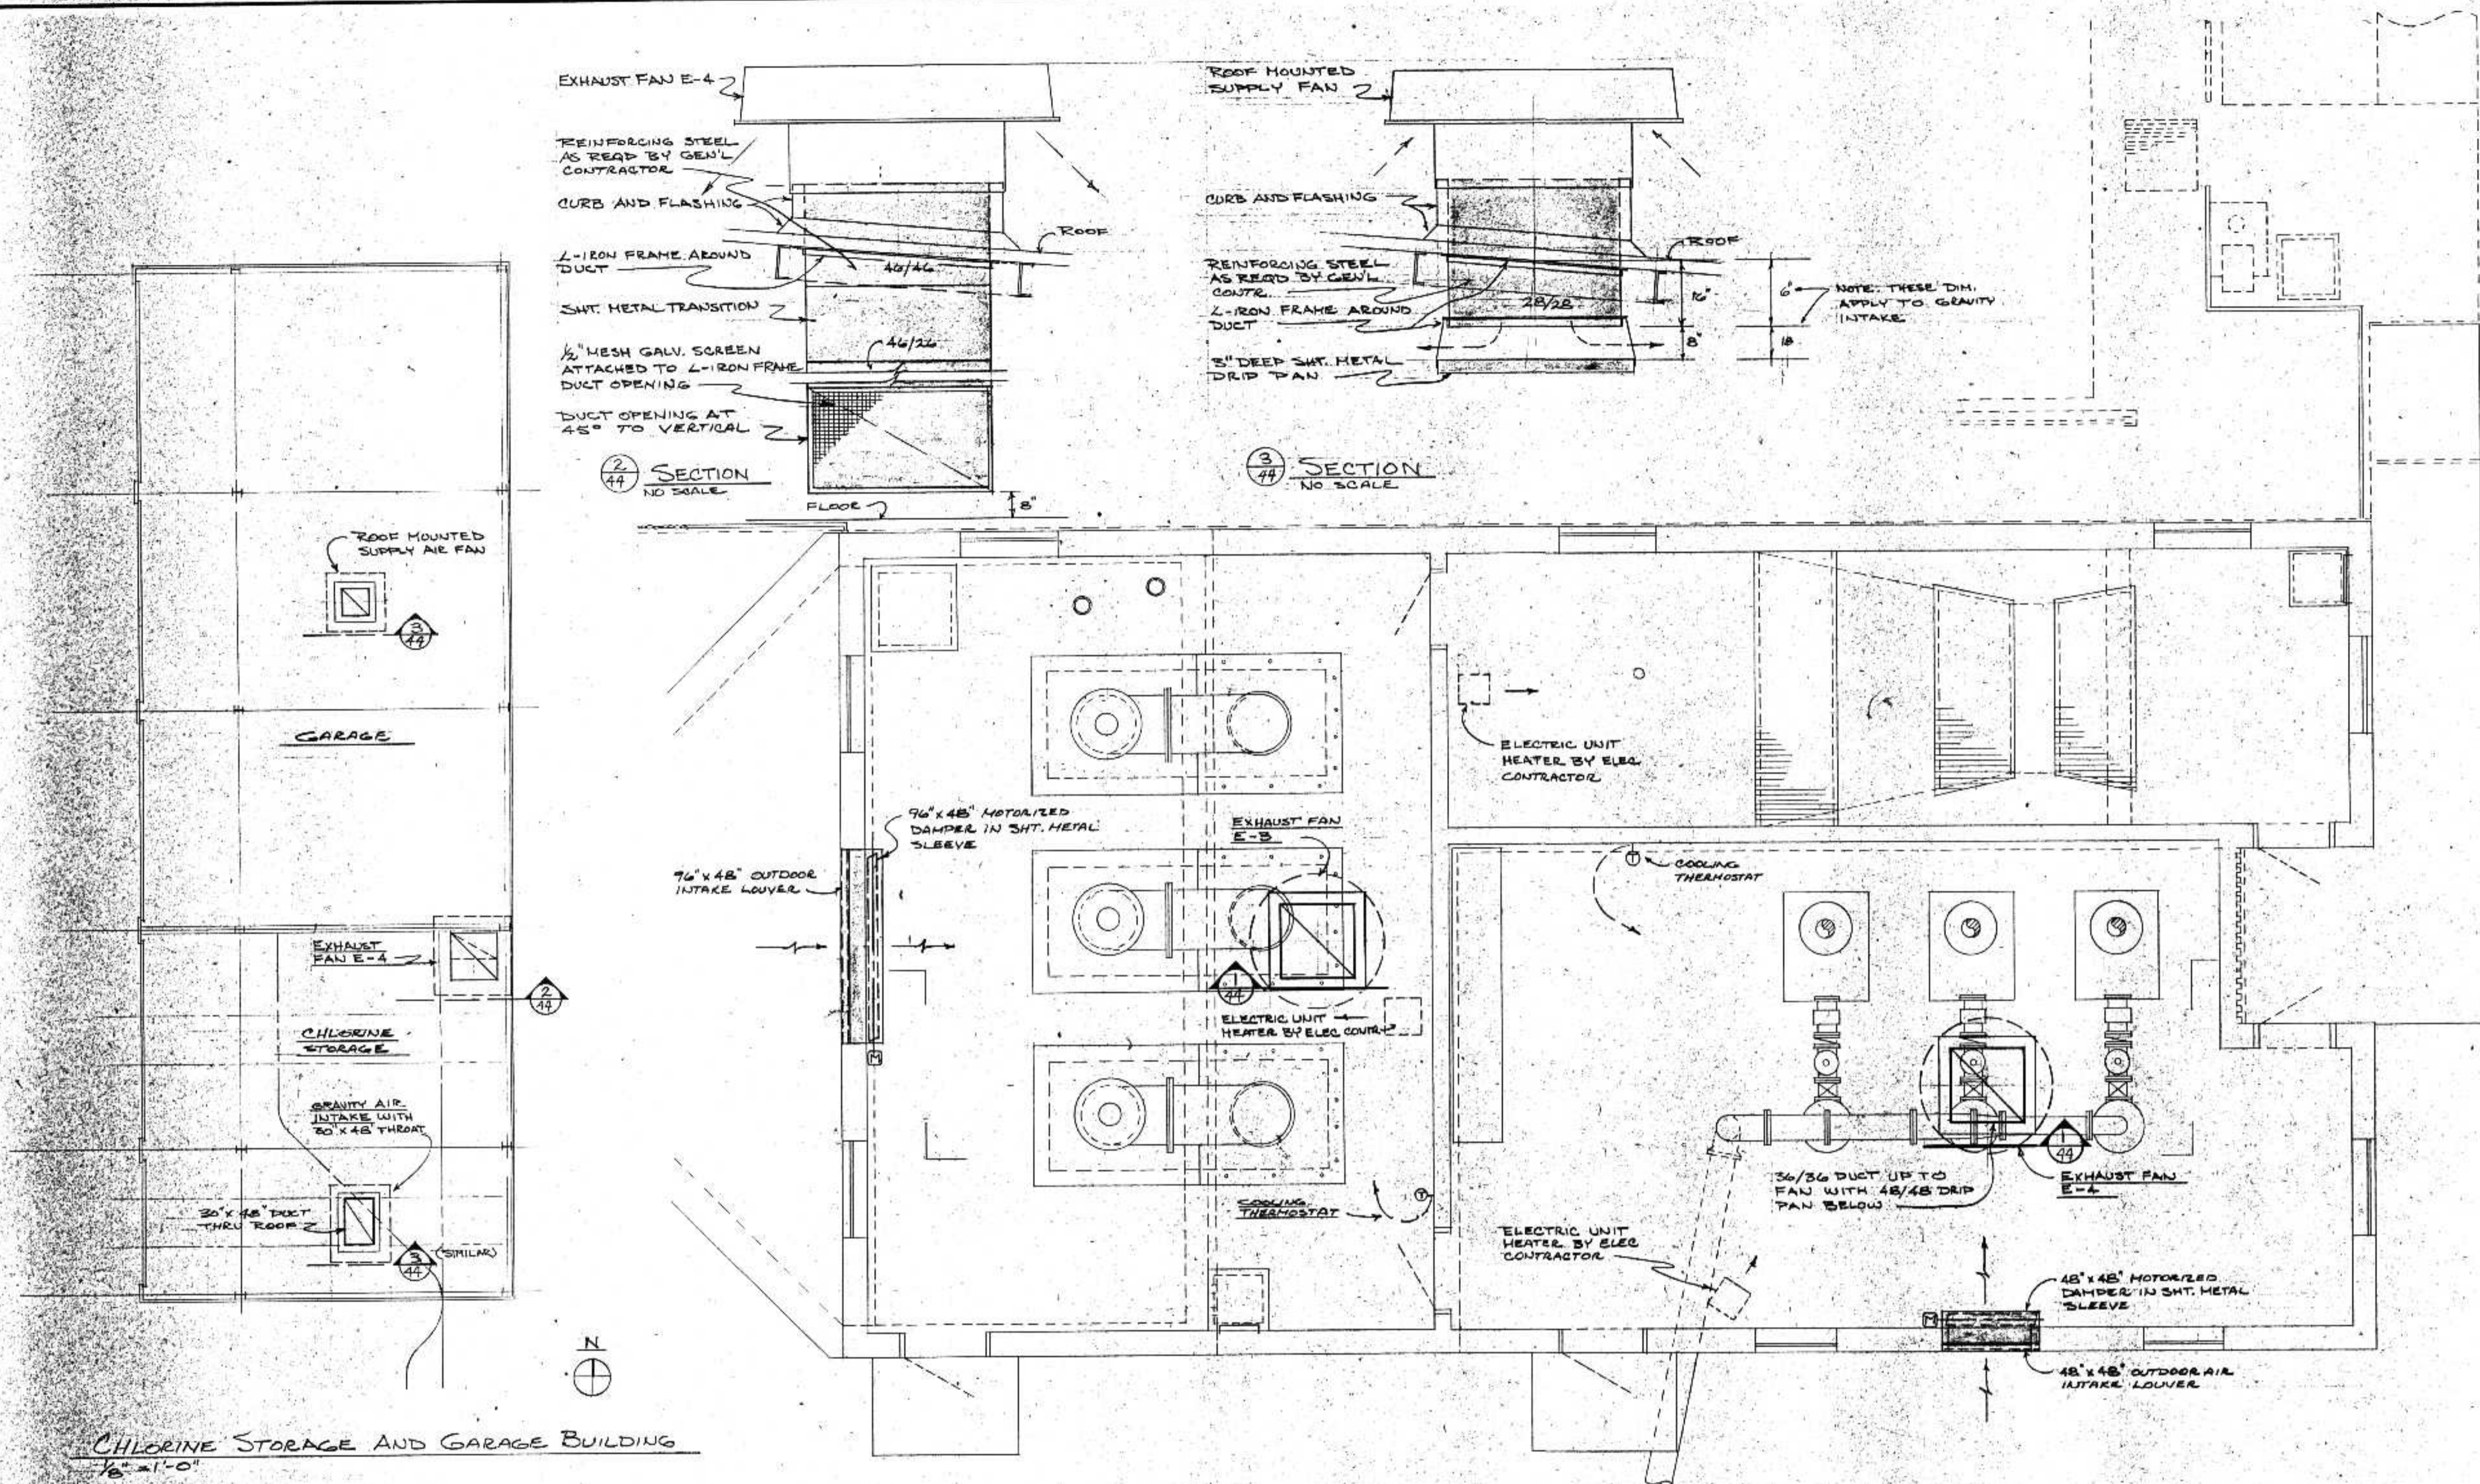

CHLORINE STORAGE AND GARAGE BUILDING
SCALE 1/8" = 1'-0"

PUMP AND BLOWER BUILDING PLAN
SCALE 1/8" = 1'-0"

ERICKSEN ELLISON
AND ASSOCIATES INC.
CONSULTING ENGINEERS
SAINT PAUL, MINNESOTA

PERMIT TO CONSTRUCTION
DATE: JUNE 14, 1975
E 6773

SURVEY
DRAWN
CHECKED
APPROVED

BONESTROO, ROSENE, ANDERLIX & ASSOC., INC.
ST. PAUL, MINNESOTA

SUPERIOR, WISCONSIN
DATE: JUNE 14, 1975
COMM 6888 F

PUMP AND BLOWER BUILDING &
C.S.O. STORAGE VENTILATING