
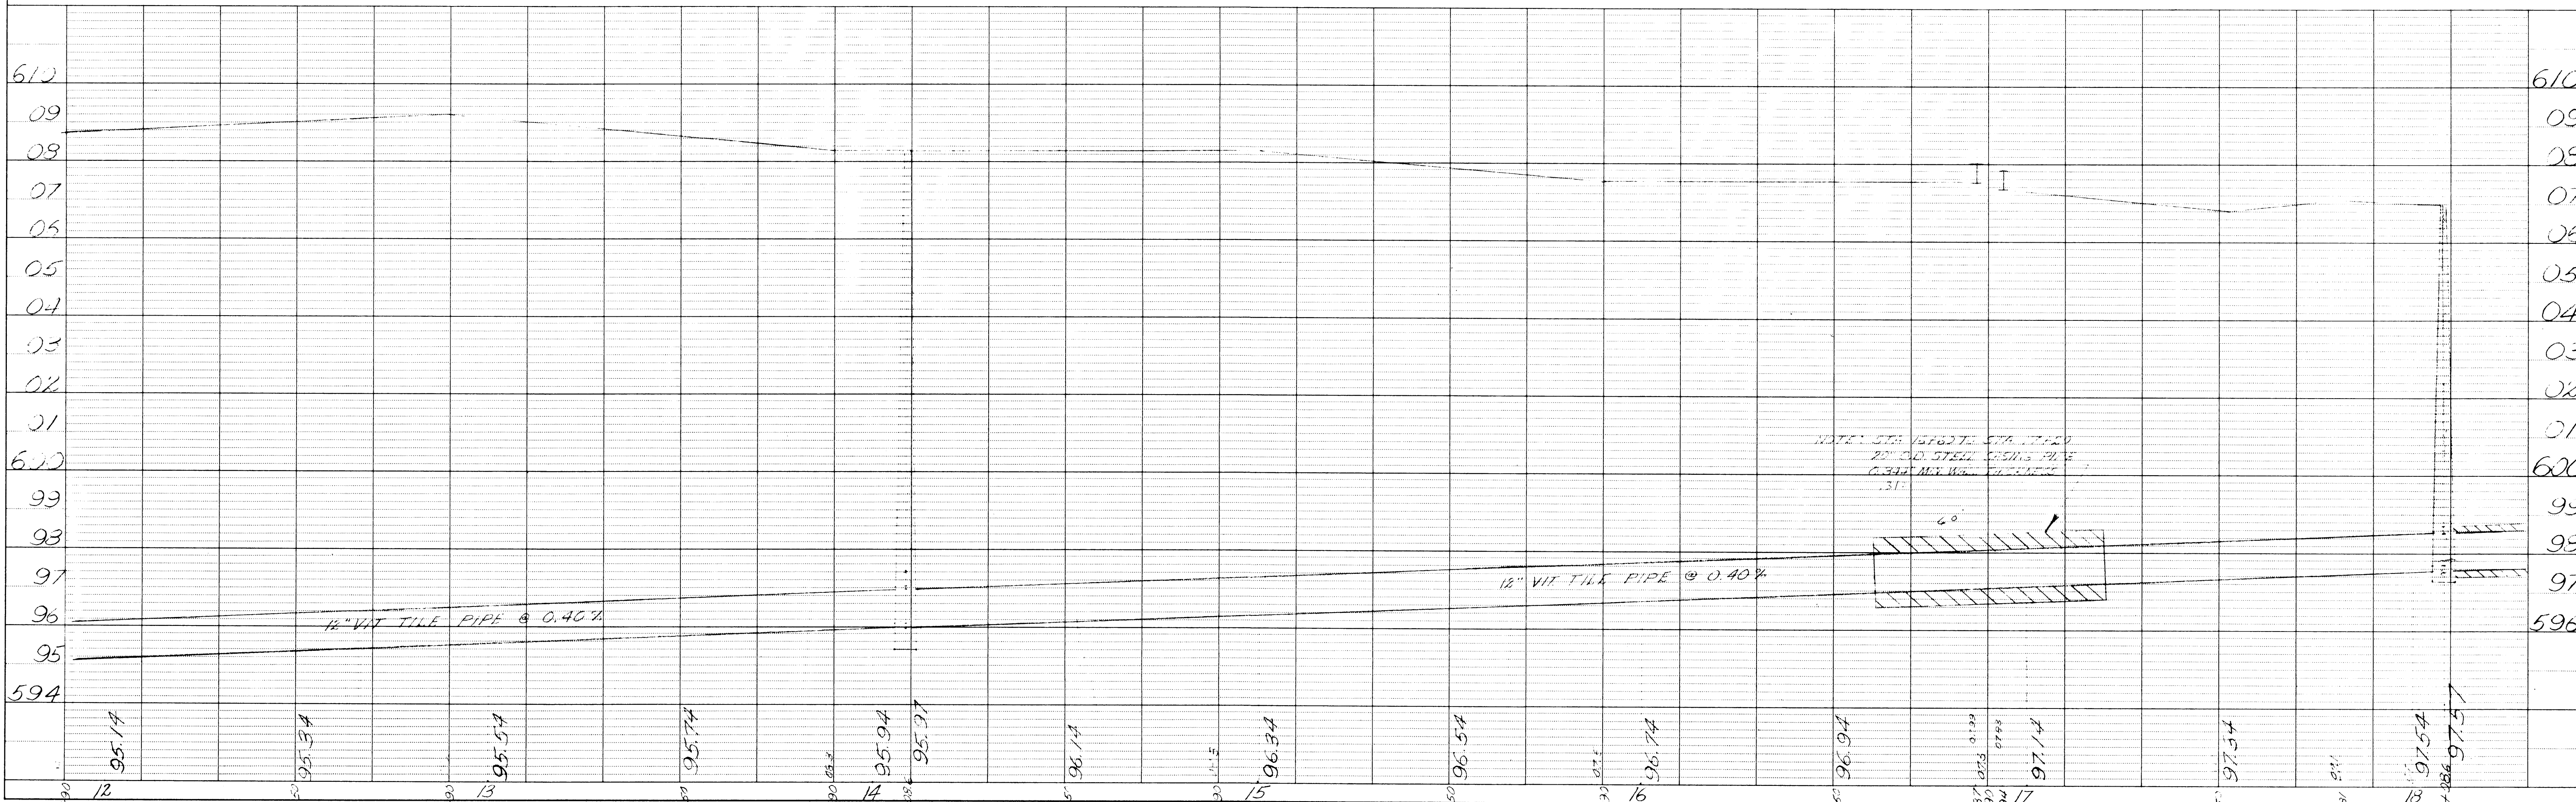


FED. ROAD DIST. No.	STATE	FEDERAL PROJ. NO.	FISCAL YEAR	SHEET No.	TOTAL SHEETS
				3	4

PLAN	SURVEYED	DATE
	BY	
NOTE BOOK NO.	PLOTTED	
	ALIGNED	
CHECKED	BY	
	DATE	

PROFILE	SURVEYED	DATE
	BY	
NOTE BOOK NO.	PLOTTED	
	BY	
CHECKED	BY	
	DATE	

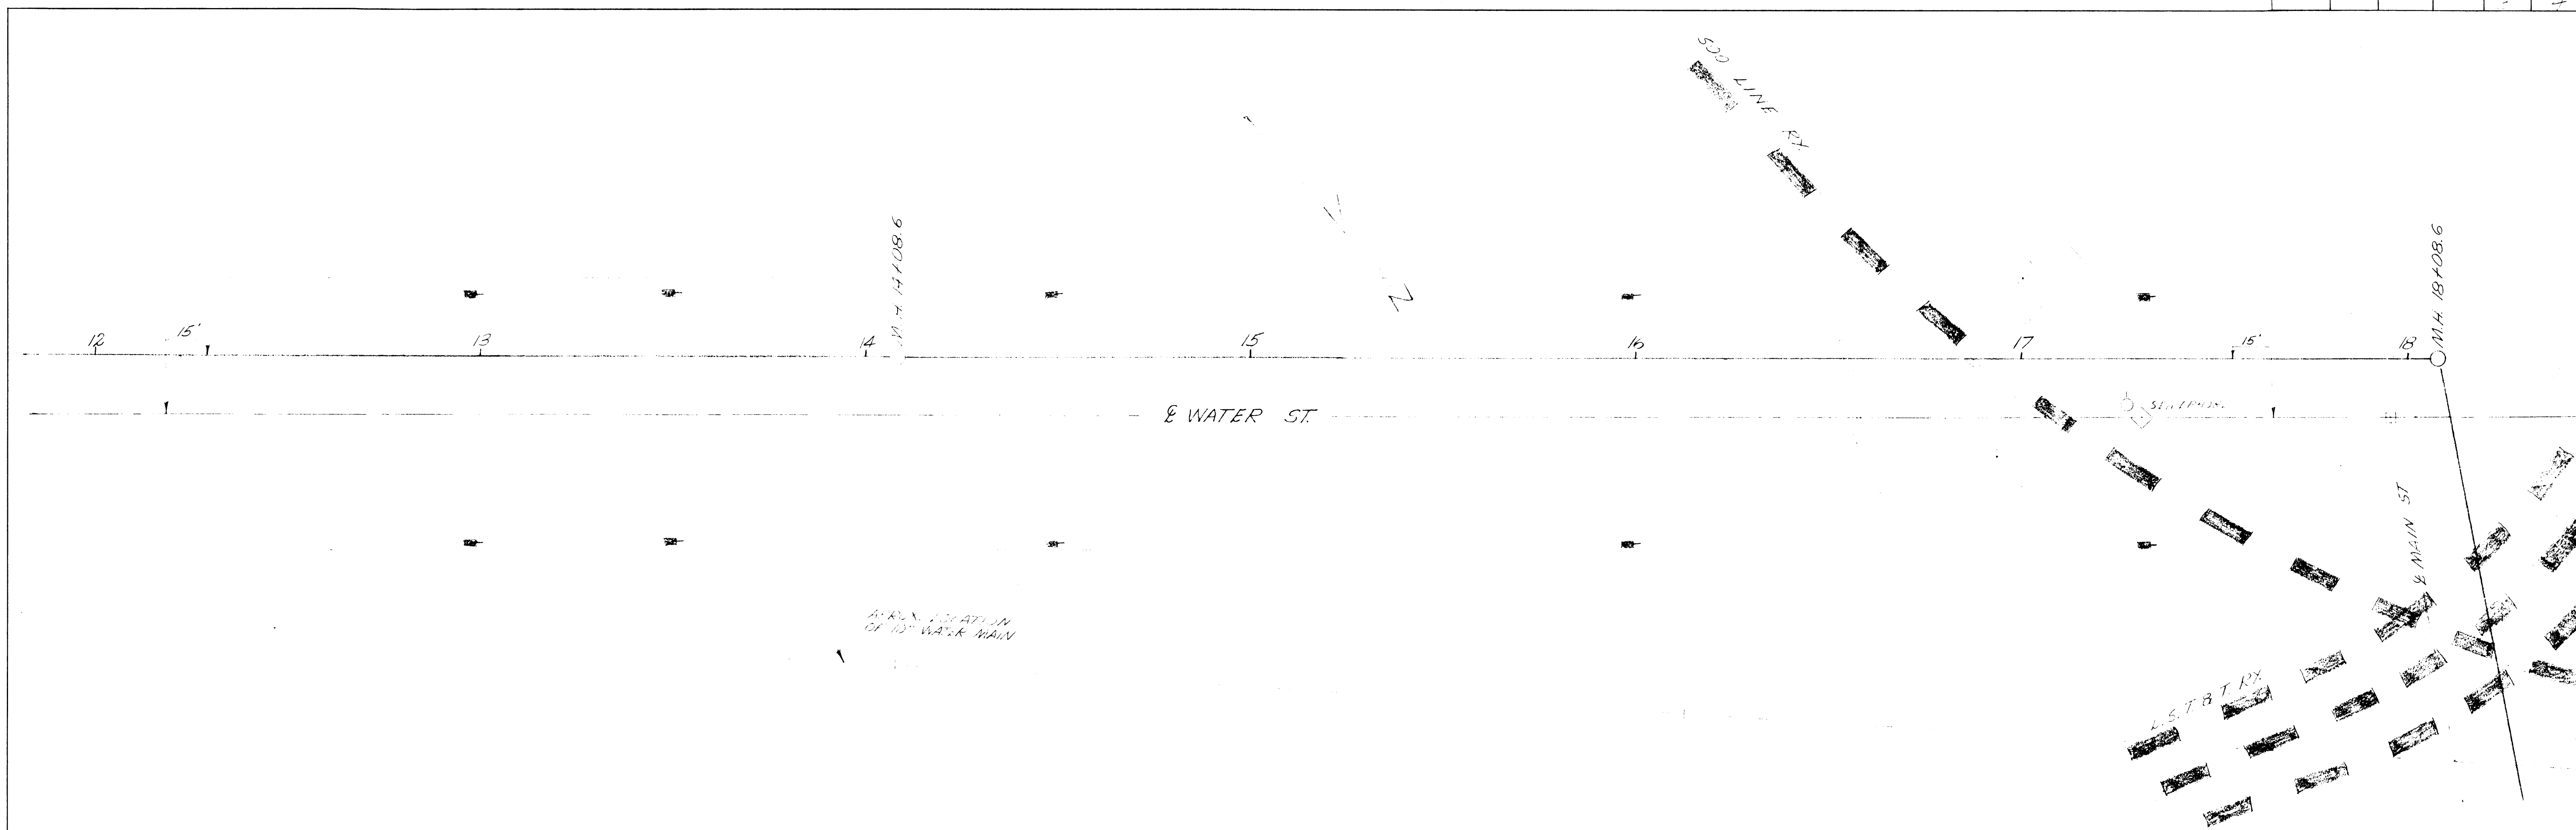

SINGLE PLAN AND PROFILE - DOTTED
 H. A. ROGERS CO. - MINNEAPOLIS - ST. PAUL - DULUTH

State Proj. No. _____ Sheet No. 3 of 4 Sheets

HARBOUR AND PLANT SEWER (3)
 A-13-0