



SECTION OF 10" R.C. PIPE

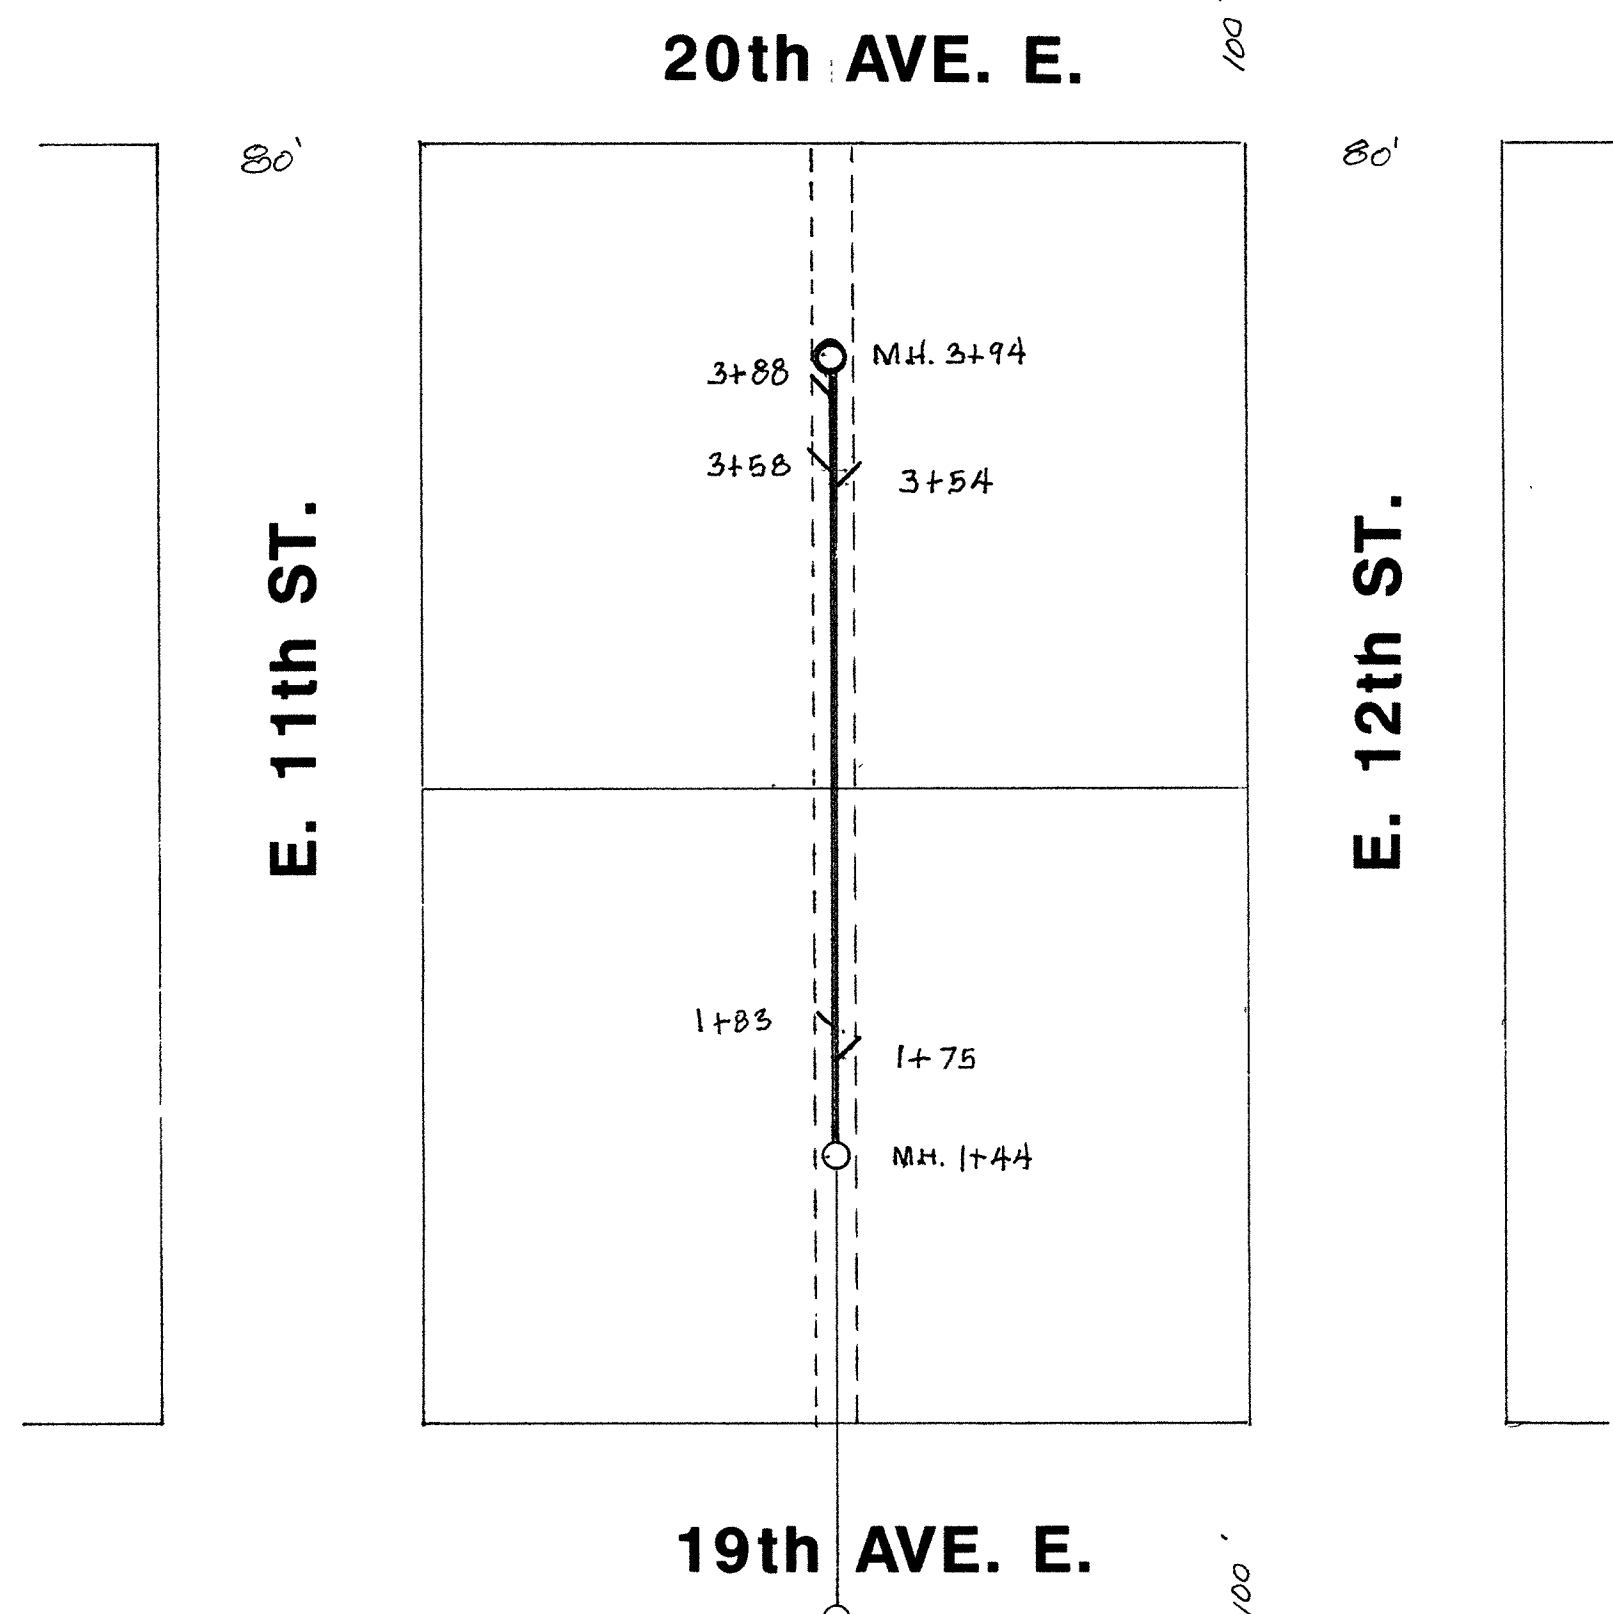


CITY OF SUPERIOR SEWER PLAN

HORIZONTAL SCALE: 1" = 60'
VERTICAL SCALE: 1" = 4'

JOB STARTED DEC. 17, 1935
JOB COMPLETED JULY 16, 1936
W.P.A. LABOR
R. H. DANN INSPECTOR
L.W. PELESKE CITY ENGINEER

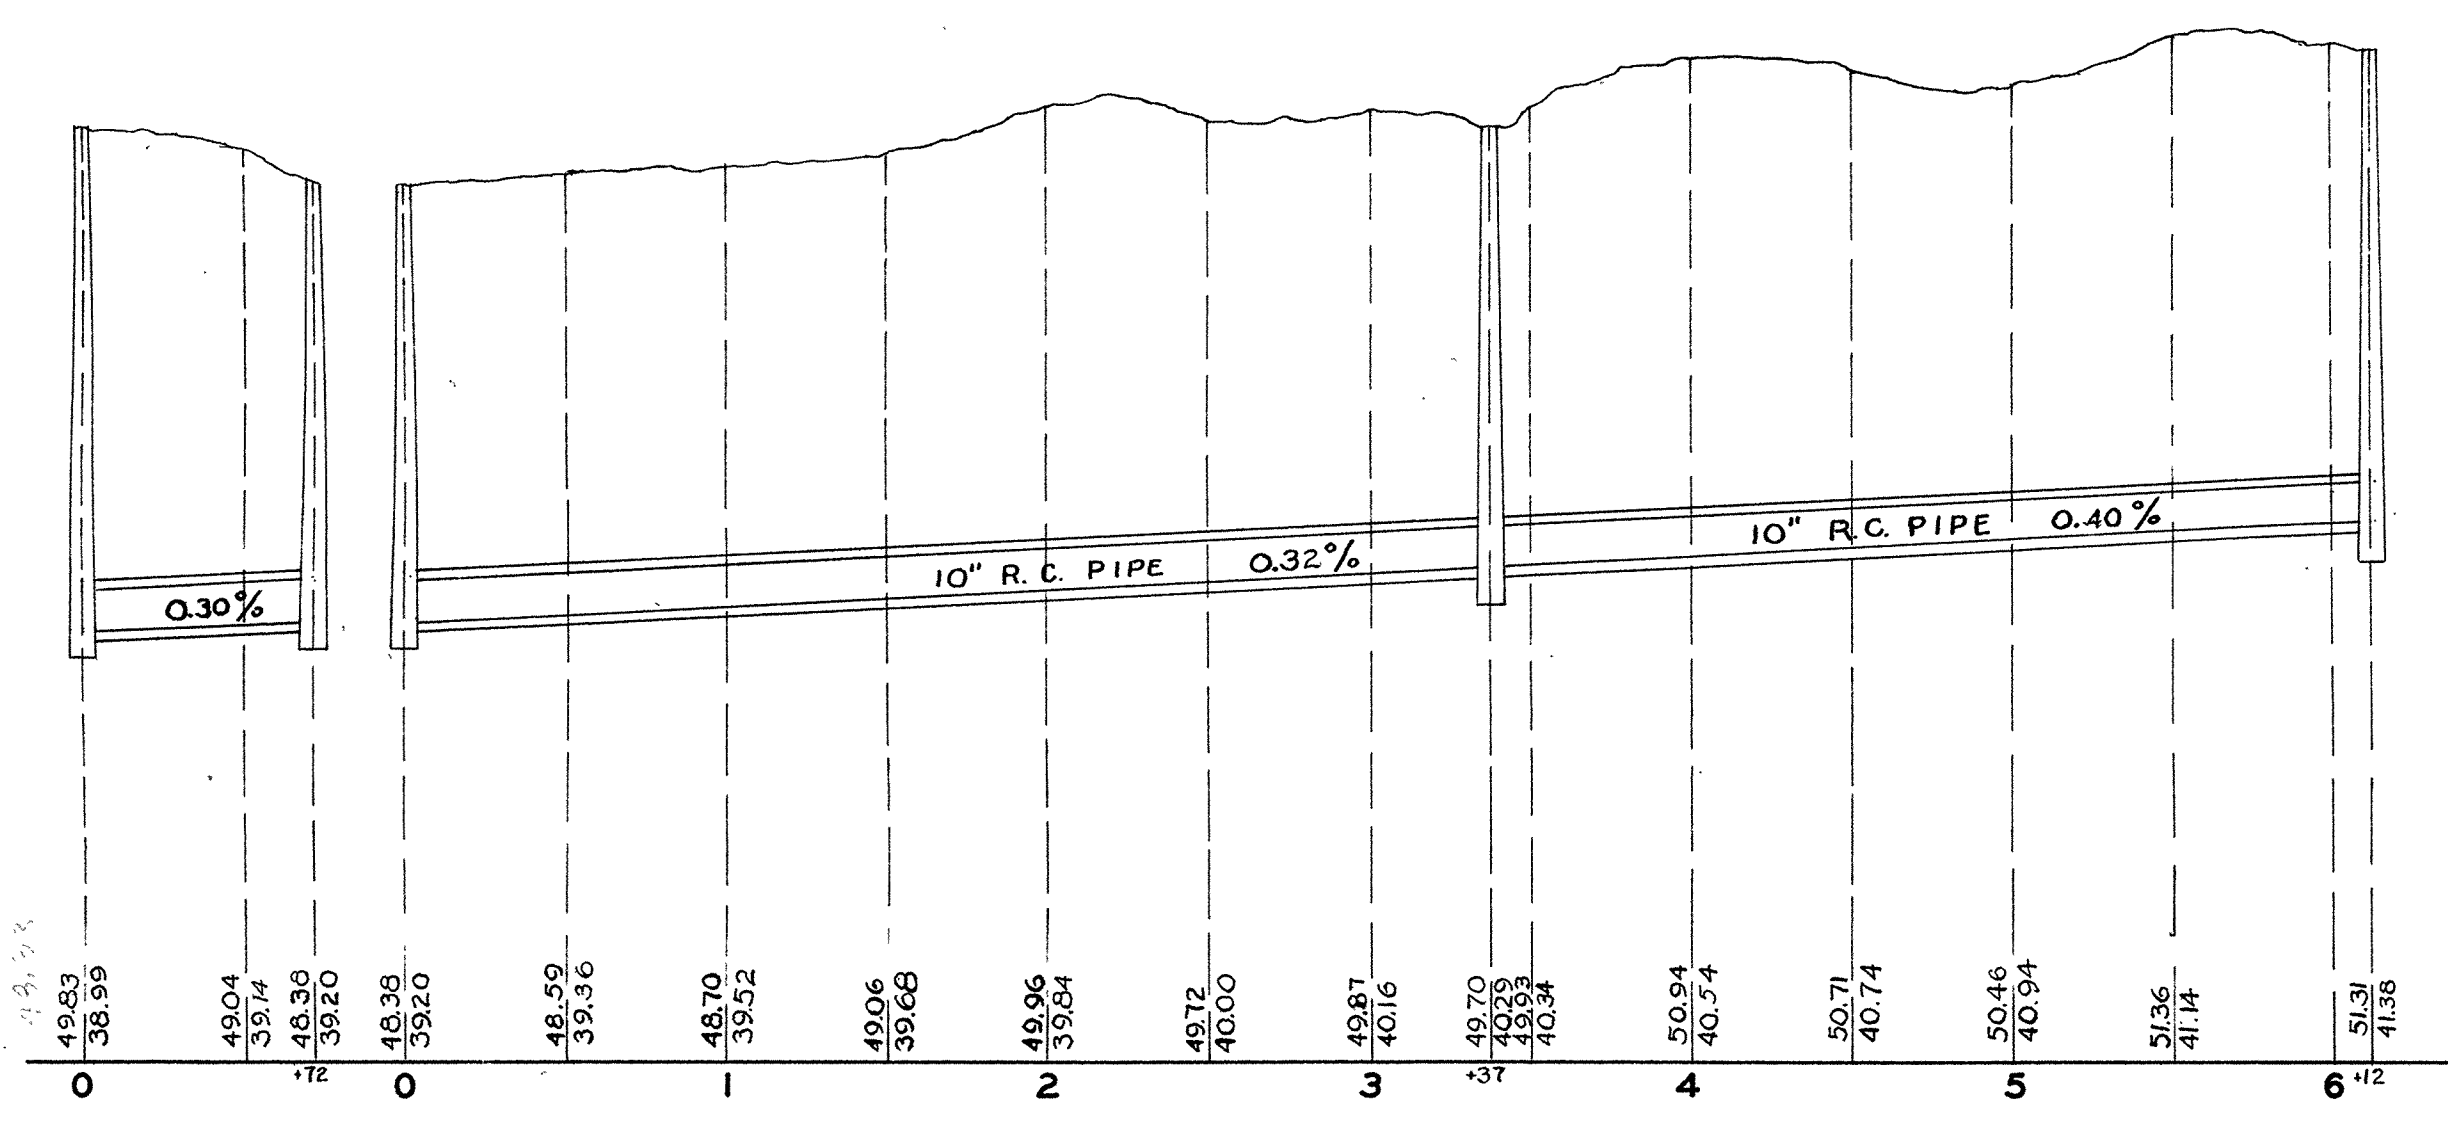

BASE LINE 30'
ABOVE CITY DATUM

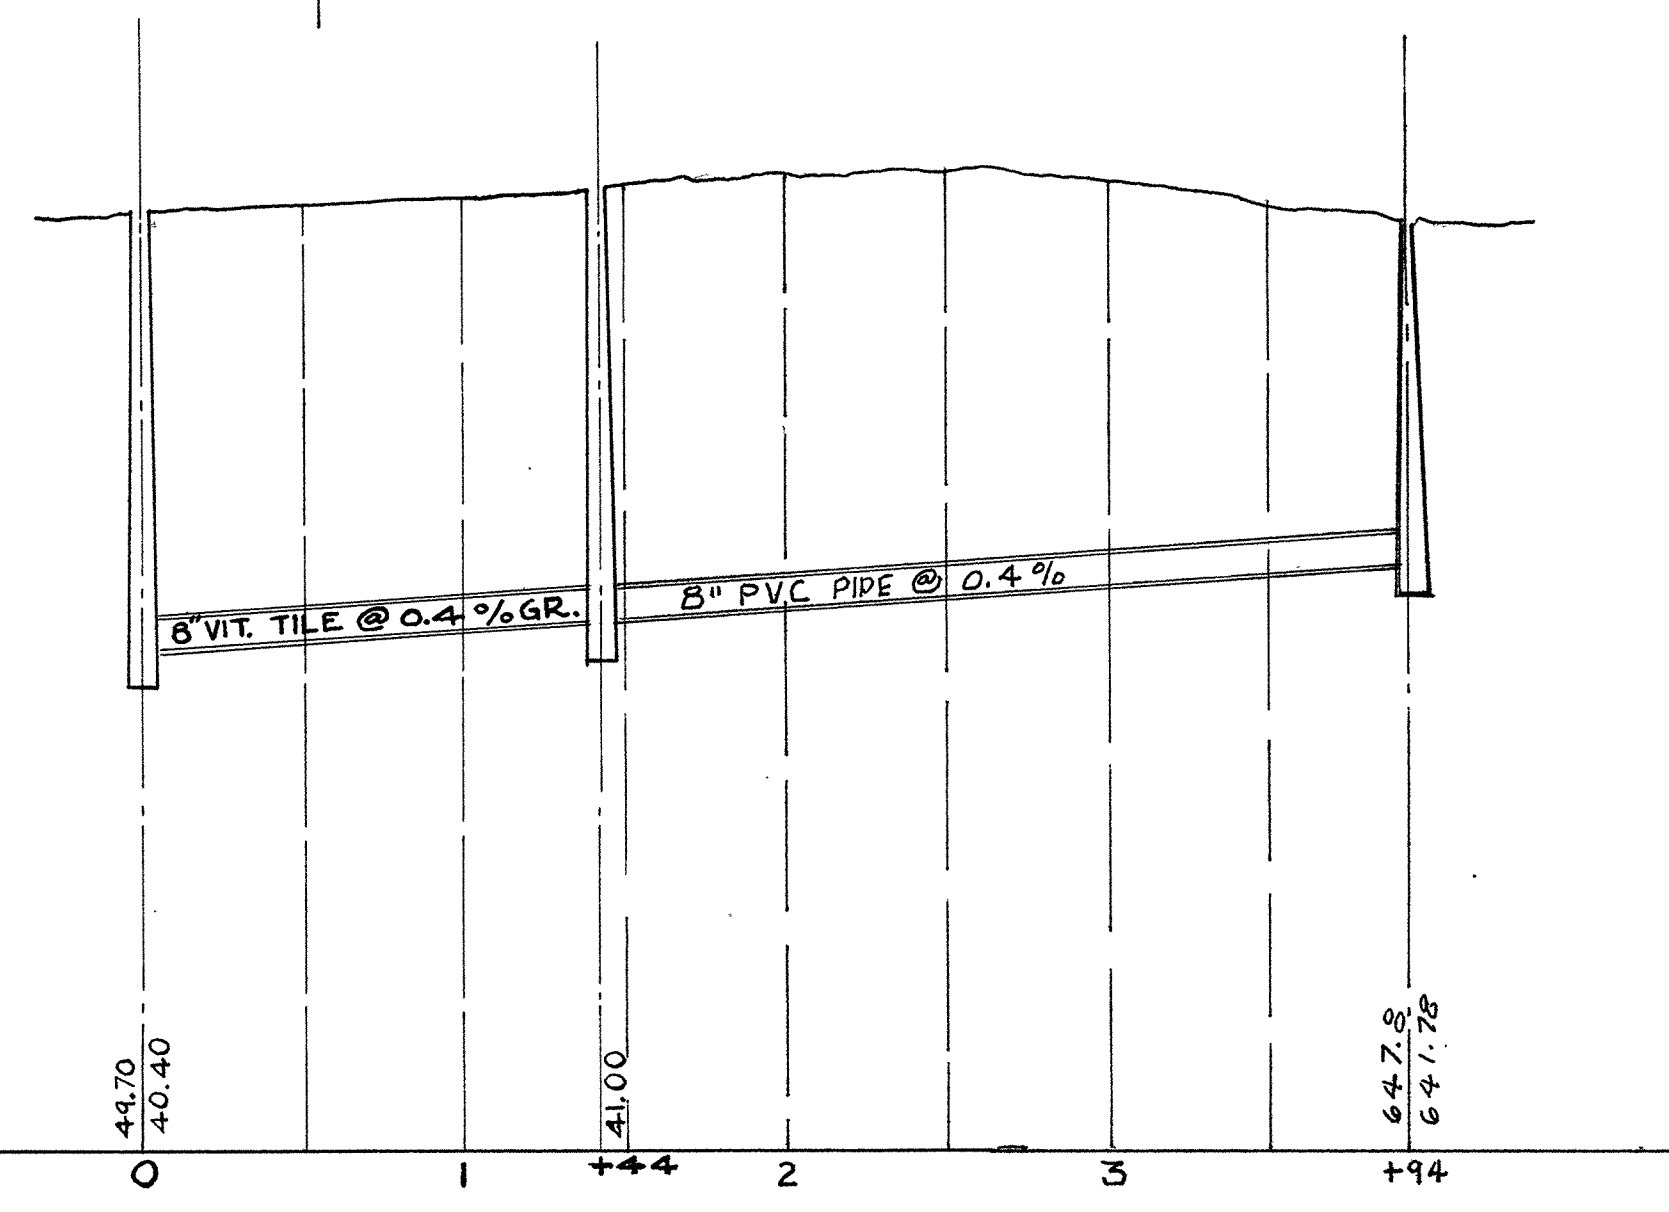

PLAN AND PROFILE OF SEWER IN ALLEY BETWEEN E.W. 11TH. & 12TH. ST. AND IN 19TH. AVE. EAST.