


**CITY OF SUPERIOR
SEWER PLAN**
 HORIZONTAL SCALE: 1" = 60'
 VERTICAL SCALE: 1" = 4'
 JOB STARTED JAN. 1937
 JOB COMPLETED APR. 1937
 W. P. A. LABOR INSPECTOR
 H. DANN
 L.W. PELESKE-CITY ENGINEER

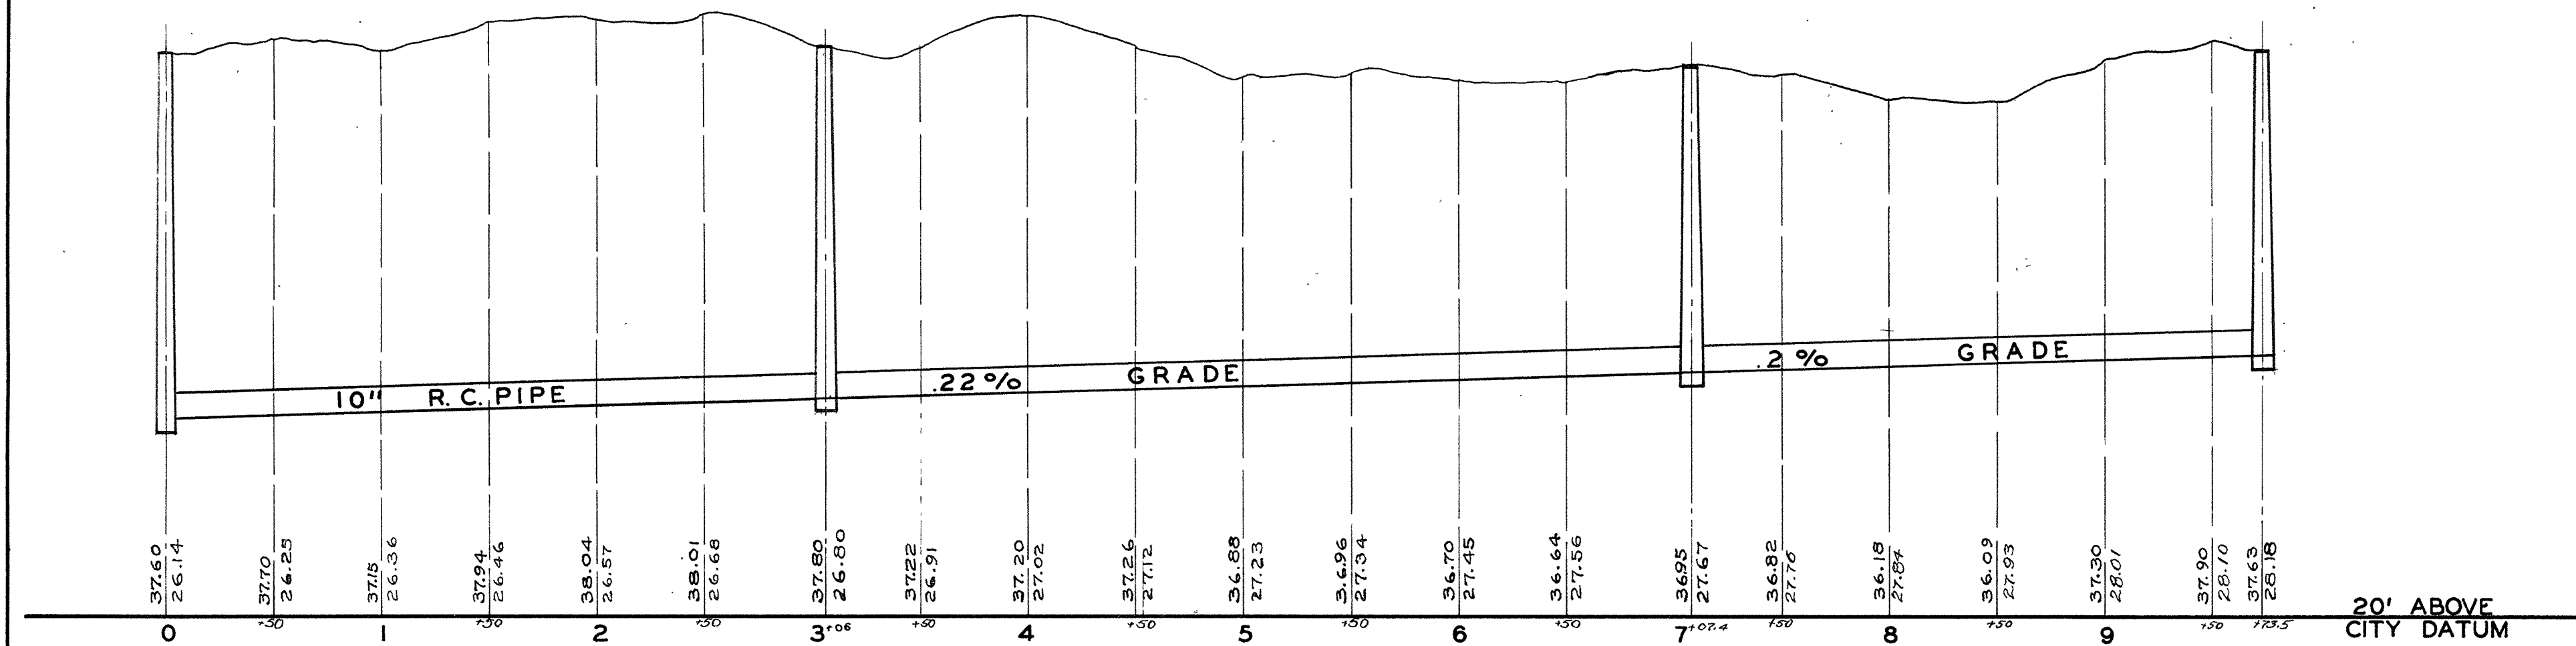

PLAN AND PROFILE OF BILLINGS PARK SECOND POINT SEWER

20' ABOVE
CITY DATUM

6-4310

6-10
WOODSTOCK

6-43