
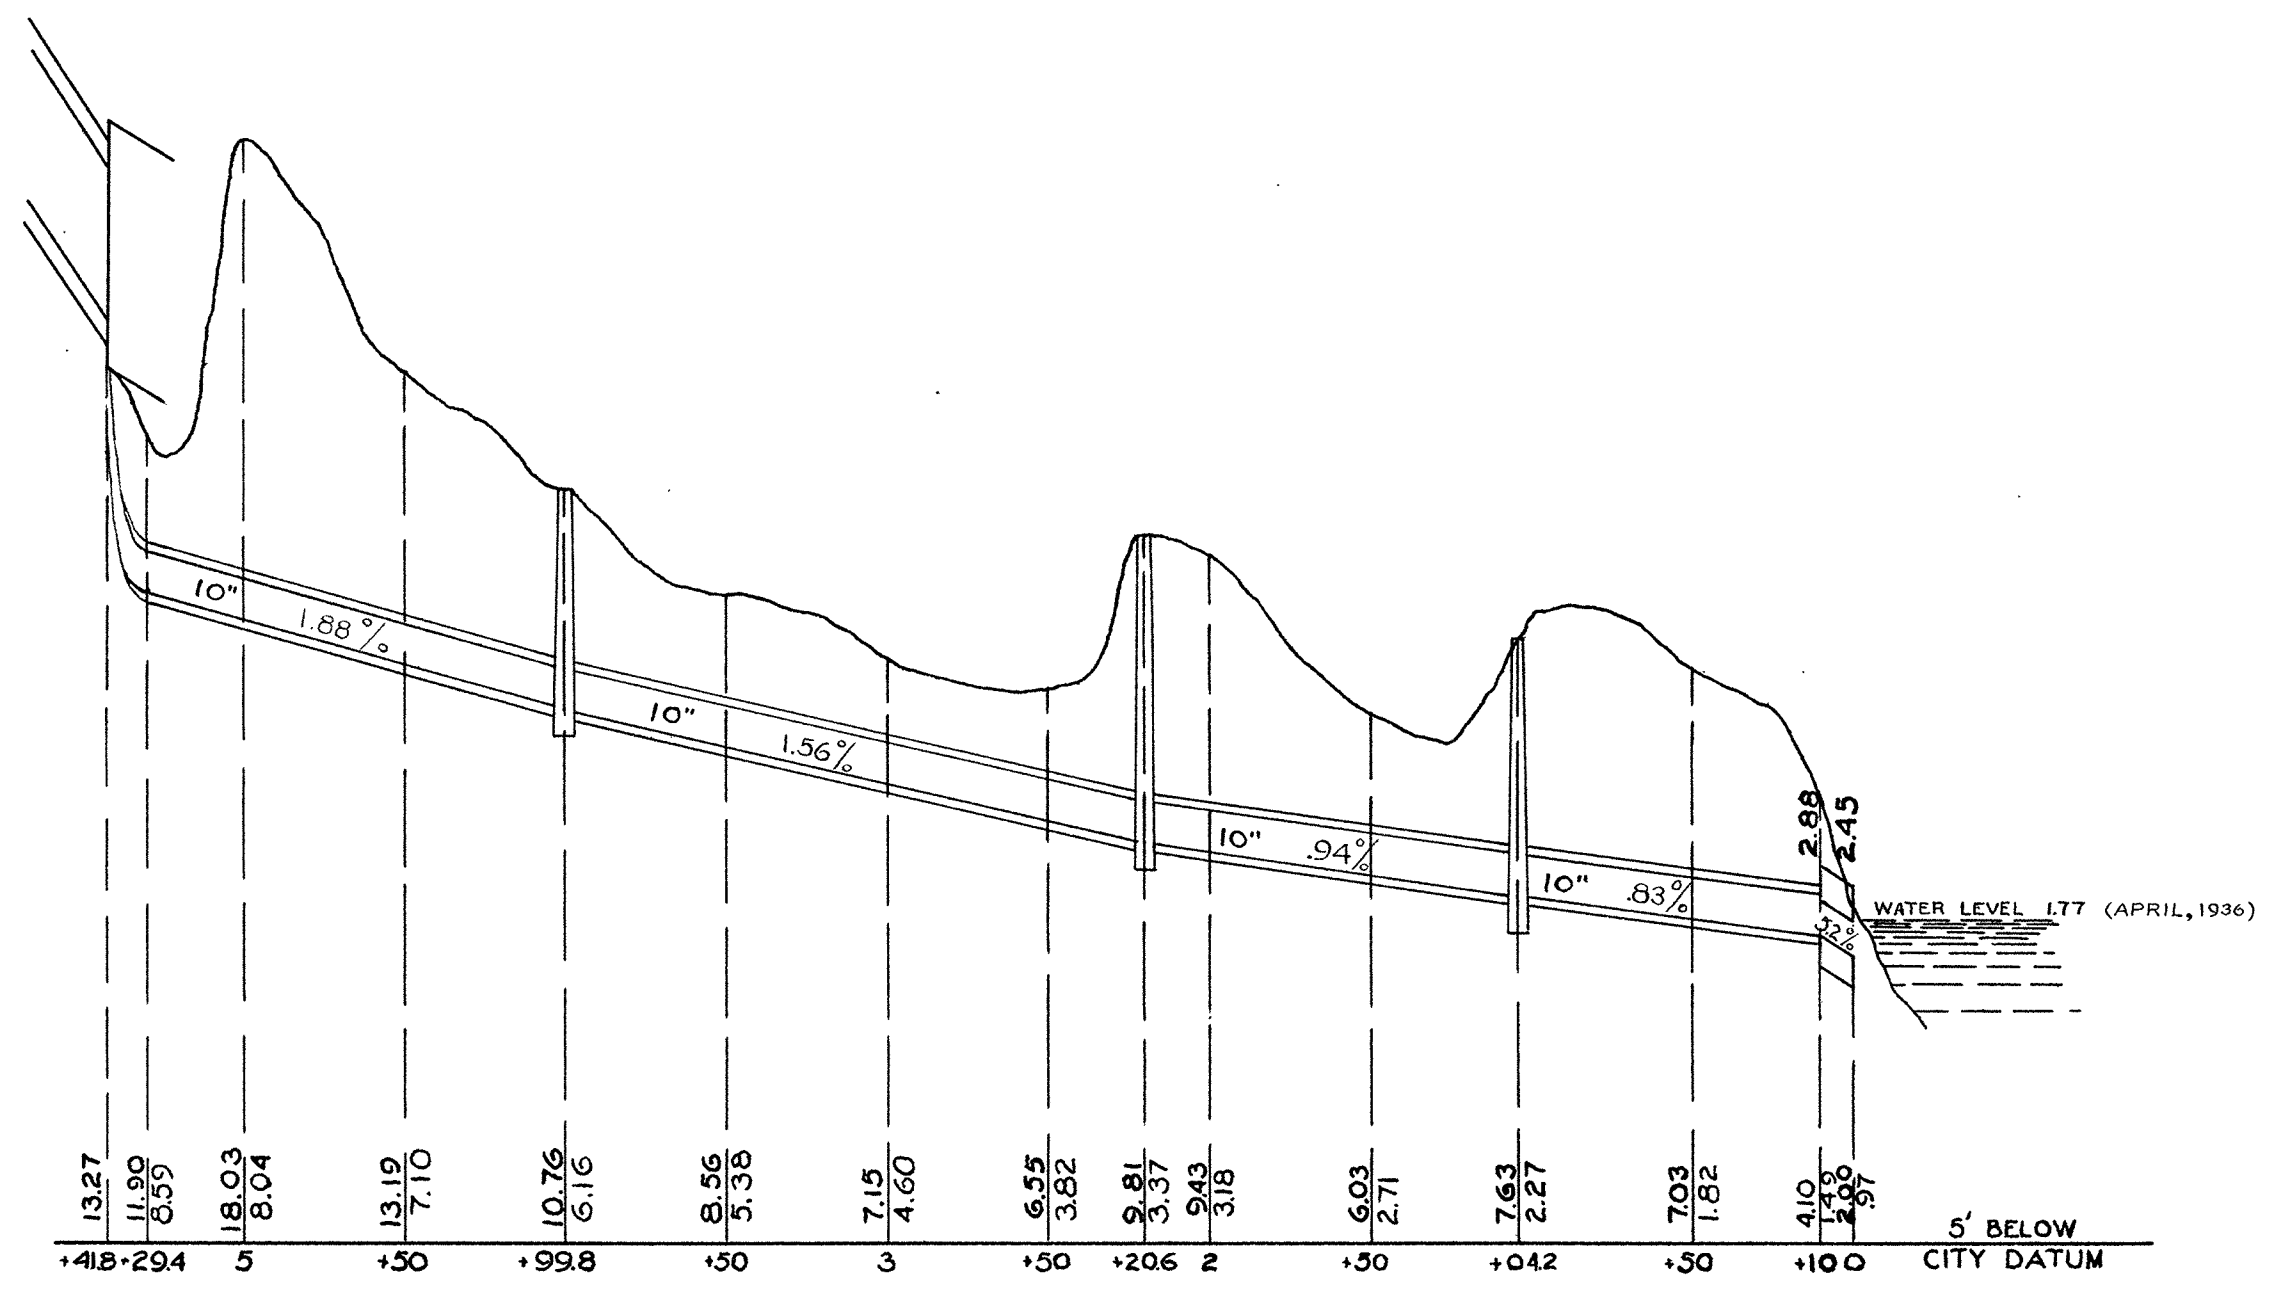
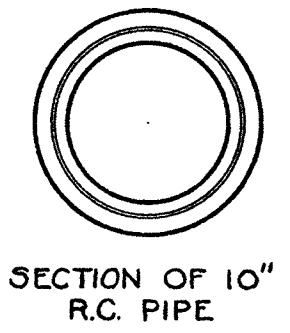


# CITY OF SUPERIOR SEWER PLAN

HORIZONTAL SCALE: 1"=60'  
VERTICAL SCALE: 1"=4'

JOB STARTED JAN, 1936  
JOB COMPLETED APRIL, 1936  
W.P.A. LABOR  
B. ANDERSON INSPECTOR  
L.W. PELESKE CITY ENGINEER

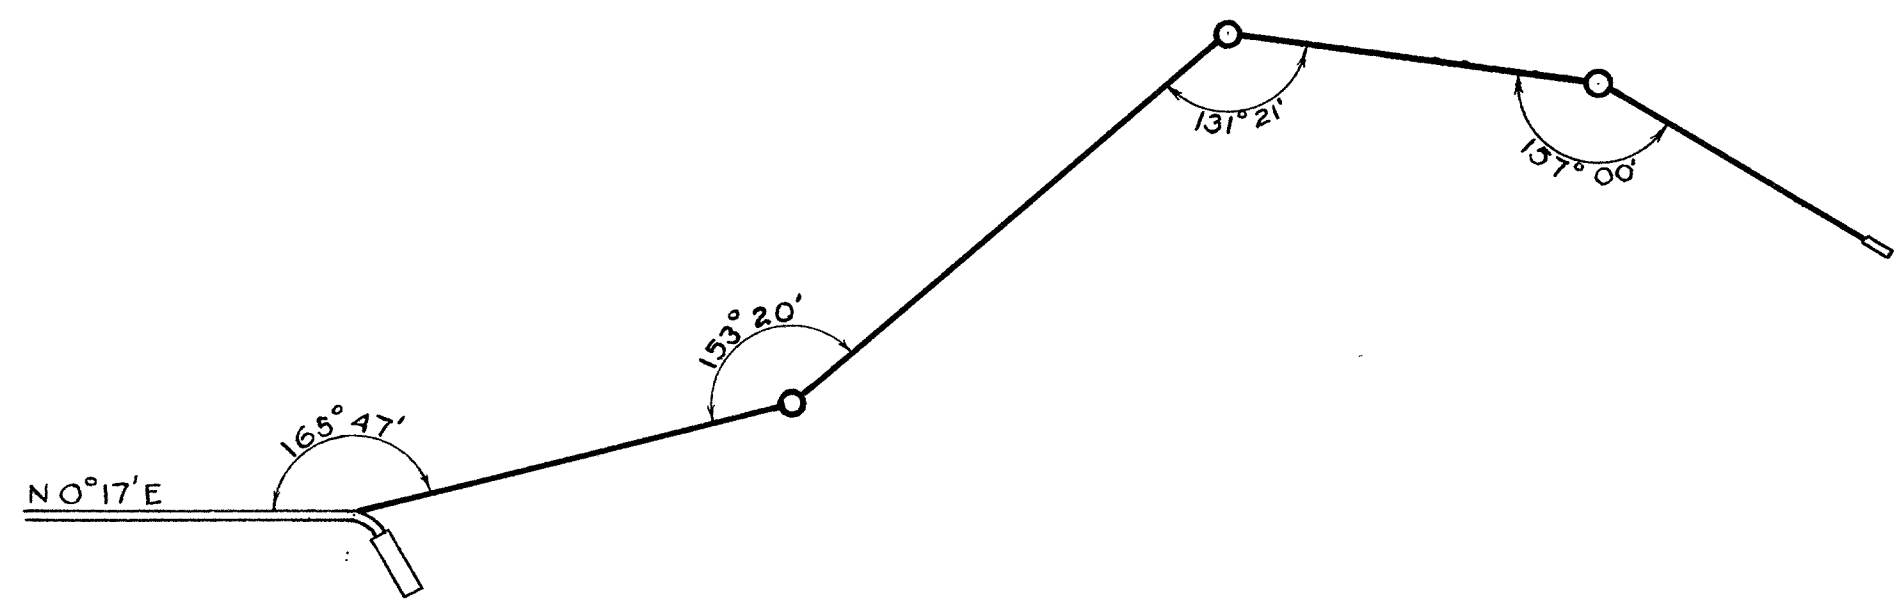

PLAN AND PROFILE OF 10 IN. R.C. SEWER BEYOND 30 IN. STORM SEWER IN WOODSTOCK DIVISION

6-42