


STORM SEWER/UTILITY PLAN

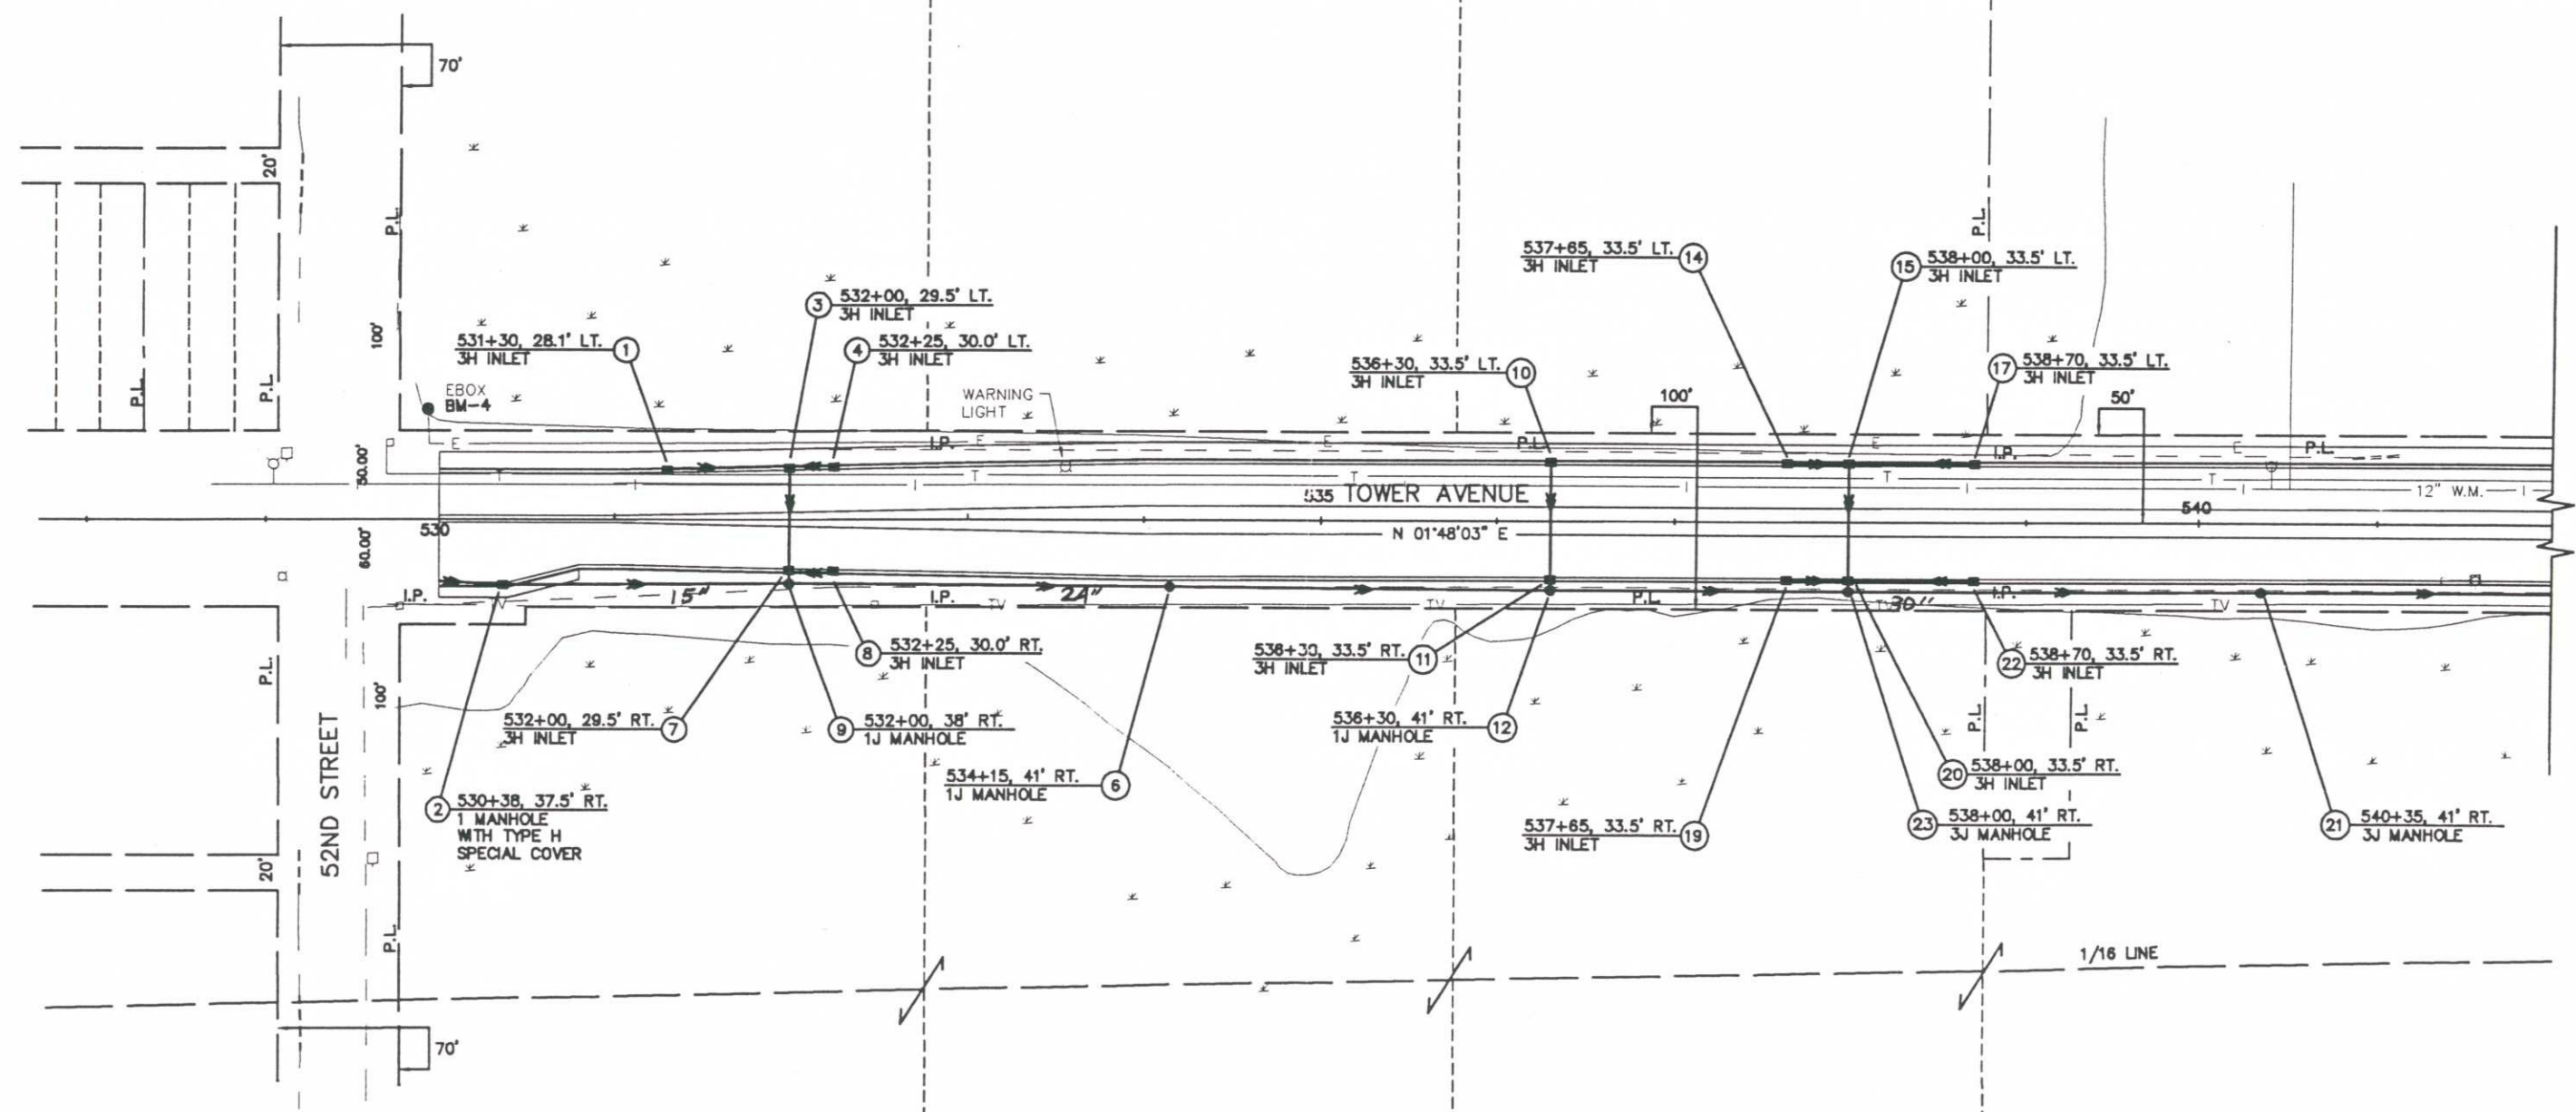

DRAWING NAME: 232000/UT  
LAYER: 07