


CITY OF SUPERIOR
 PLAN AND PROFILE

SEWER PLAN

JOB COMPLETED SEPT. 1957
 CITY ENGINEER E.W. BERG
 HORIZONTAL SCALE 1" = 60'
 VERTICAL SCALE 1" = 4'

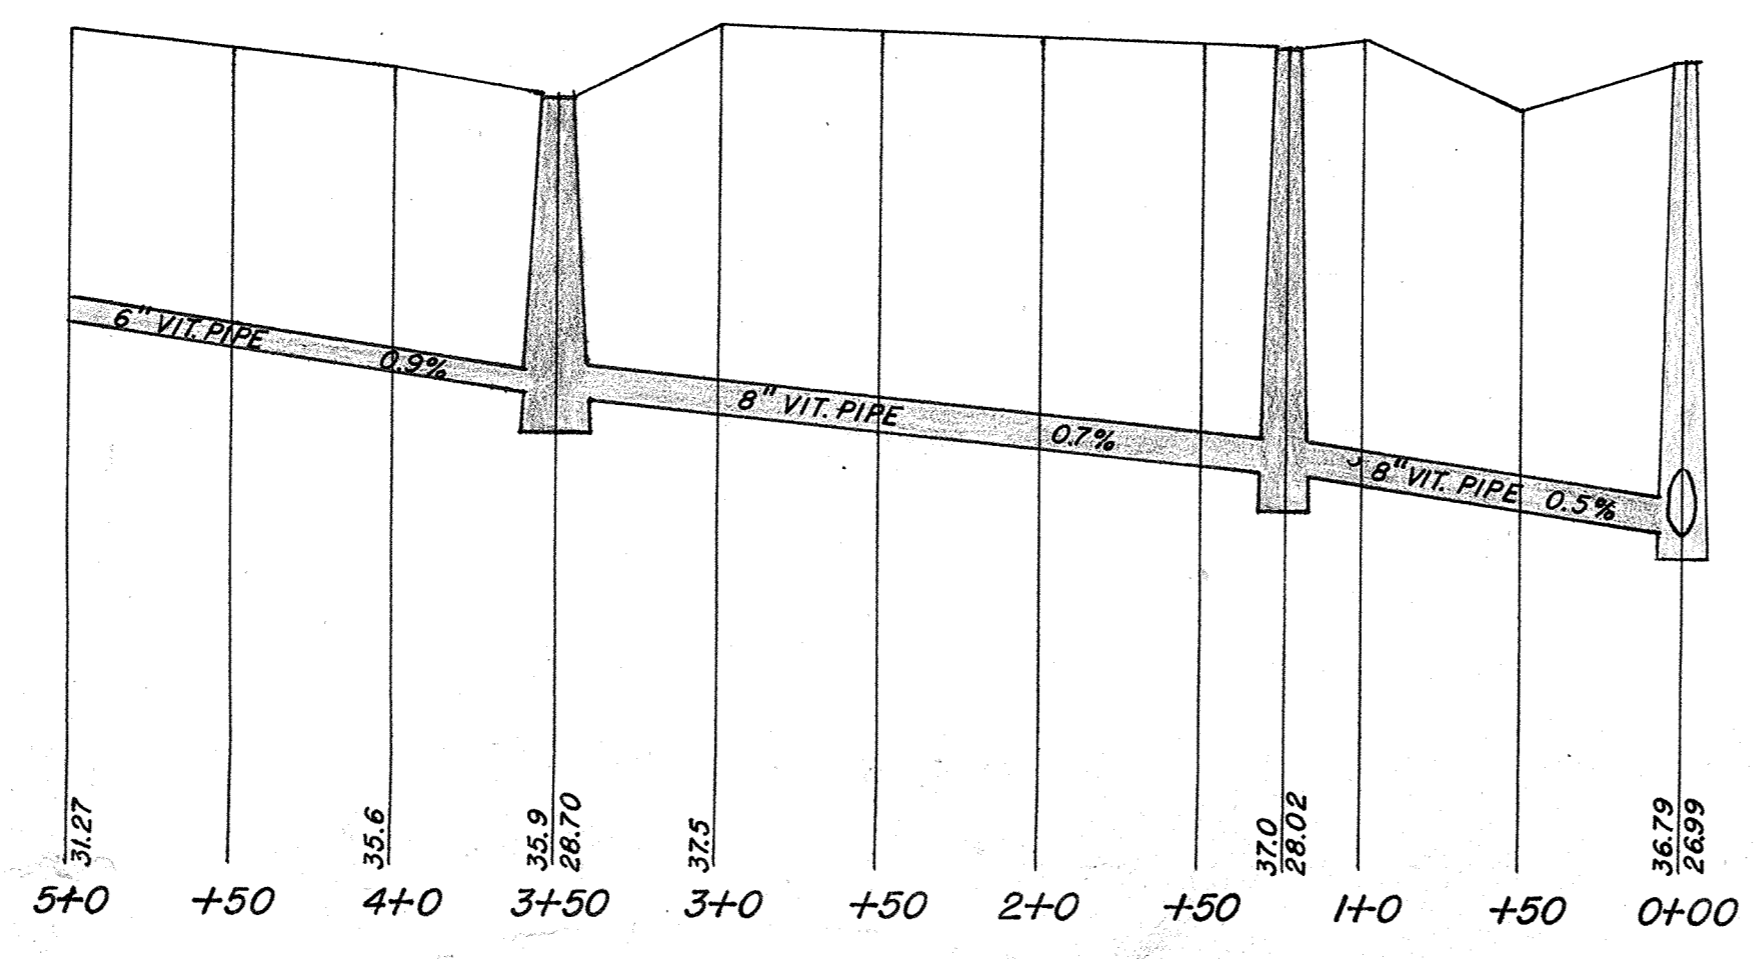

3A-33A