
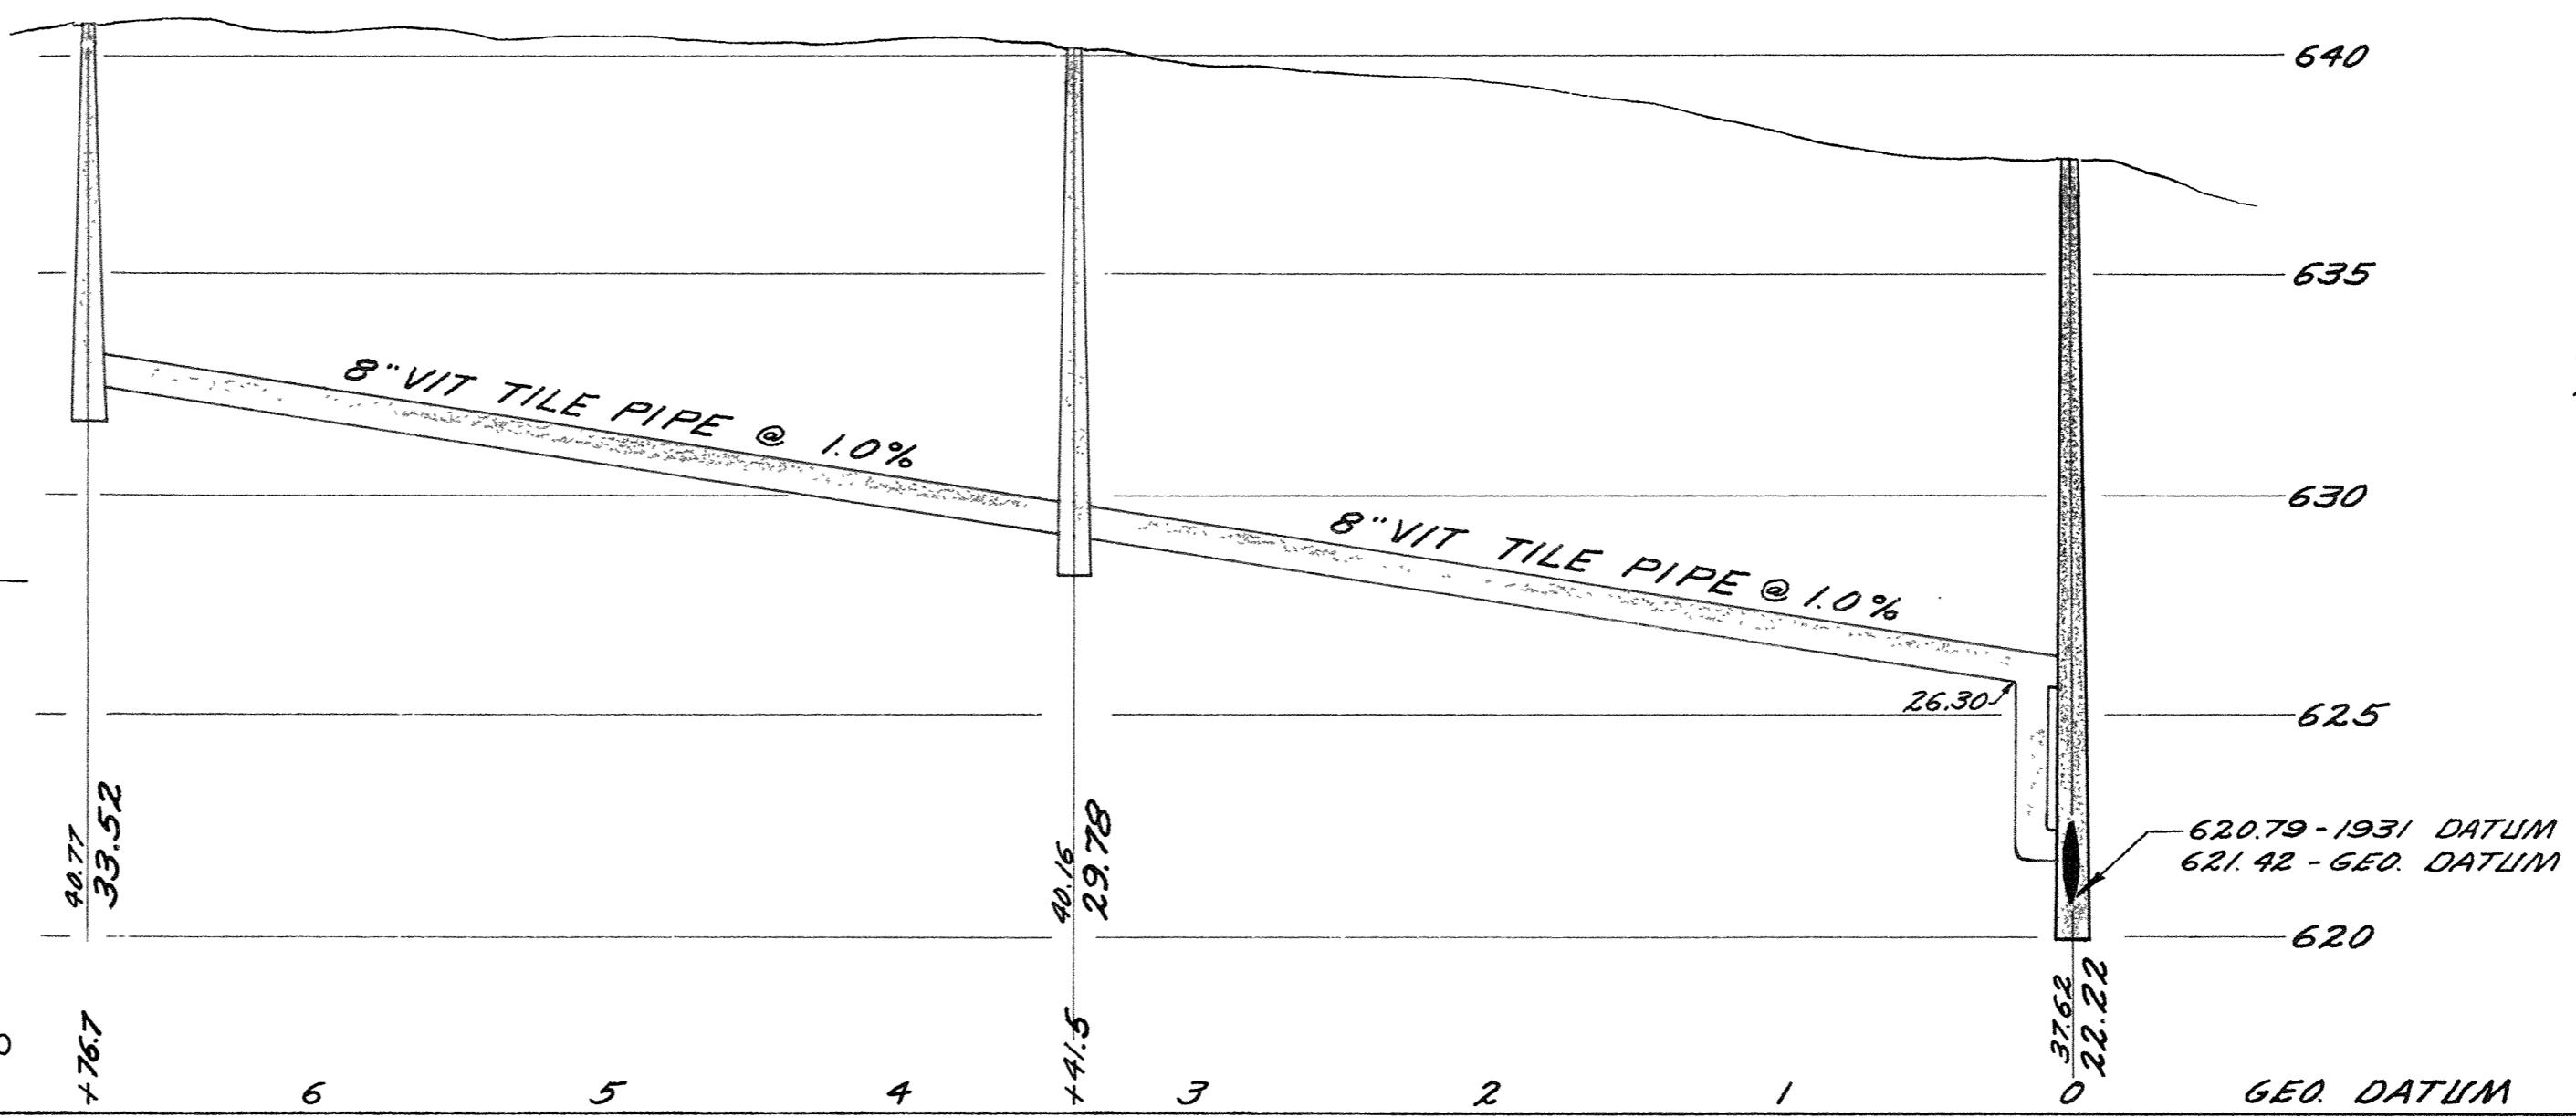


CITY OF SUPERIOR  
 PLAN AND PROFILE  
**SEWER PLAN**

JOB COMPLETED 1957.  
 CITY ENGINEER E.W. BERG  
 HORIZONTAL SCALE 1" = 60'  
 VERTICAL SCALE 1" = 4'  
 MOTOR JOINTS

NOTE: ALL JOINTS HOT POURED (ASPHALTIC BASE)

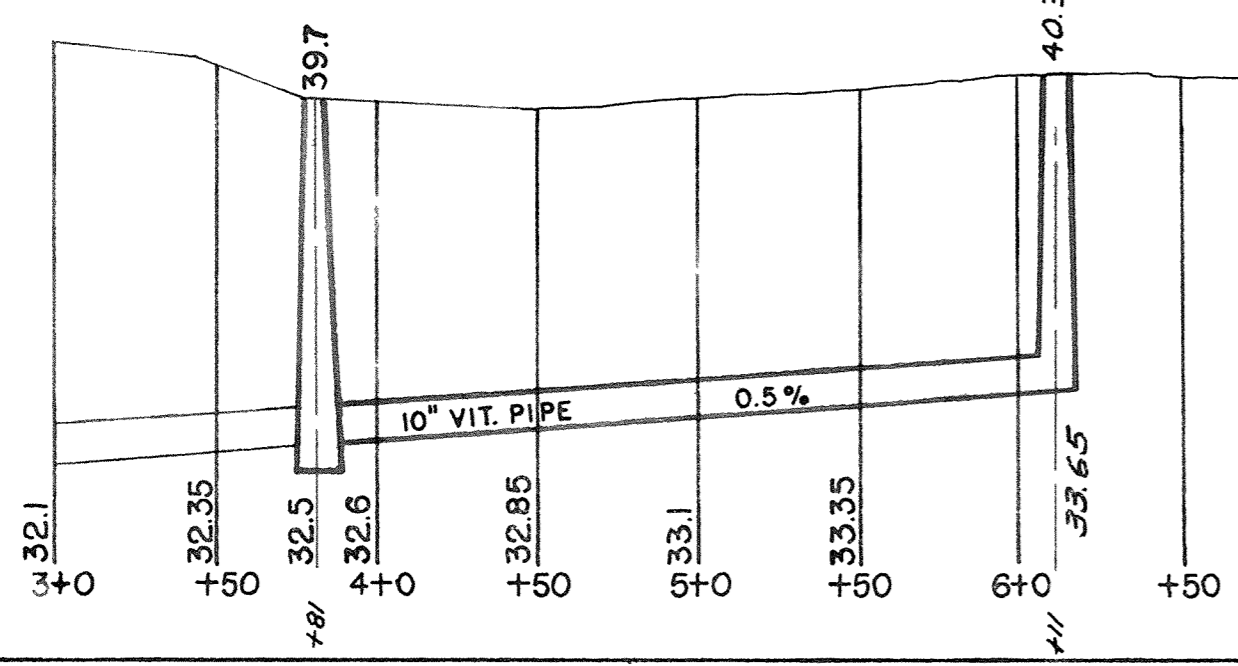

CITY OF SUPERIOR  
**SANITARY SEWER DIST. 3B**  
 JOB COMPLETED JULY 1960  
 CITY ENGINEER E.W. BERG  
 CONTRACTOR BUILDER'S SUPPLY CO.  
 HORIZONTAL SCALE 1" = 60'  
 VERTICAL SCALE 1" = 4'

3B-14A