

BIRCH AVE.

CATLIN AVE.



11<sup>TH</sup> ST.

12<sup>TH</sup> ST.

13<sup>TH</sup> ST.

14<sup>TH</sup> ST.

END OF 18" PIPE 6+17.5

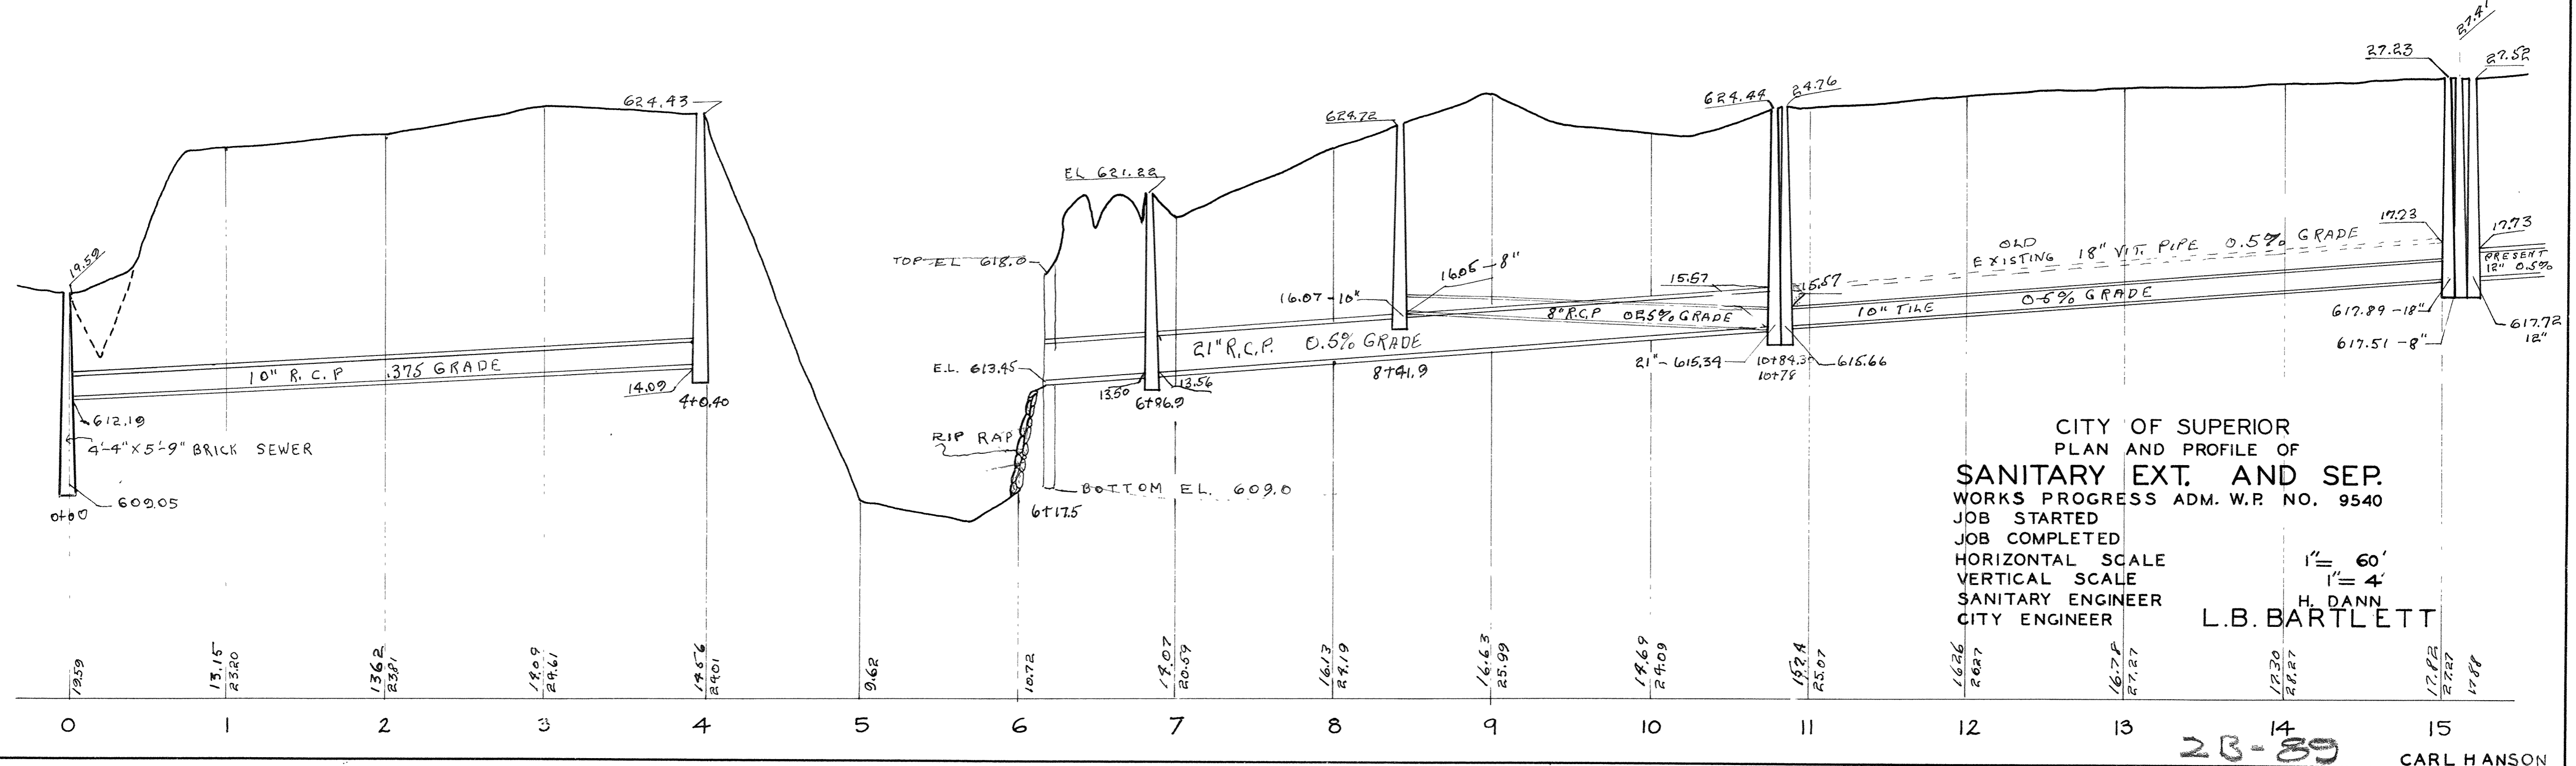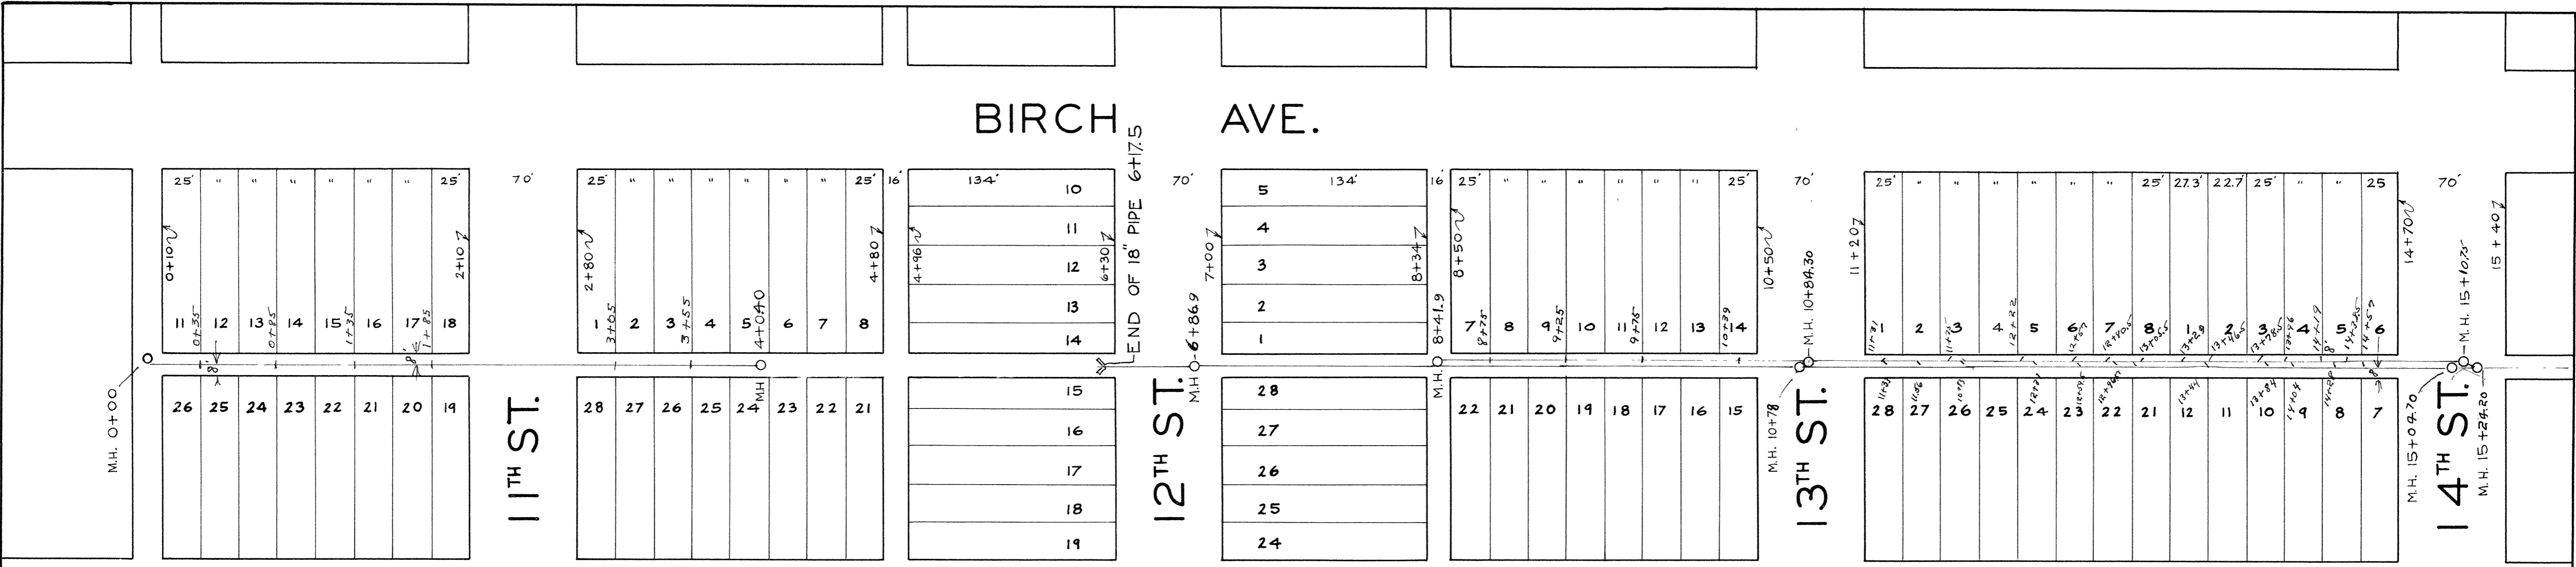

CITY OF SUPERIOR  
 PLAN AND PROFILE OF  
**SANITARY EXT. AND SEP.**  
 WORKS PROGRESS ADM. W.P. NO. 9540  
 JOB STARTED  
 JOB COMPLETED  
 HORIZONTAL SCALE 1" = 60'  
 VERTICAL SCALE 1" = 4'  
 H. DANN  
 SANITARY ENGINEER  
 CITY ENGINEER  
**L.B. BARTLETT**

23-89  
 CARL HANSON  
 8/1/46