

W. FOURTH CITY OF SUPERIOR





SEWER PLAN

Contract let May 26, 1890 [Failed]
 " relet April 3, 1891
 Forrestal Bros. & F. A. Dole, Contractors
 F. Richardson, W. G. Coleman, J. P. Duff, Insps.
 E. B. Banks, City Engineer



Scale { Horizontal 1" = 60'
 Vertical 1" = 4'
 Section 1/2" = 1'

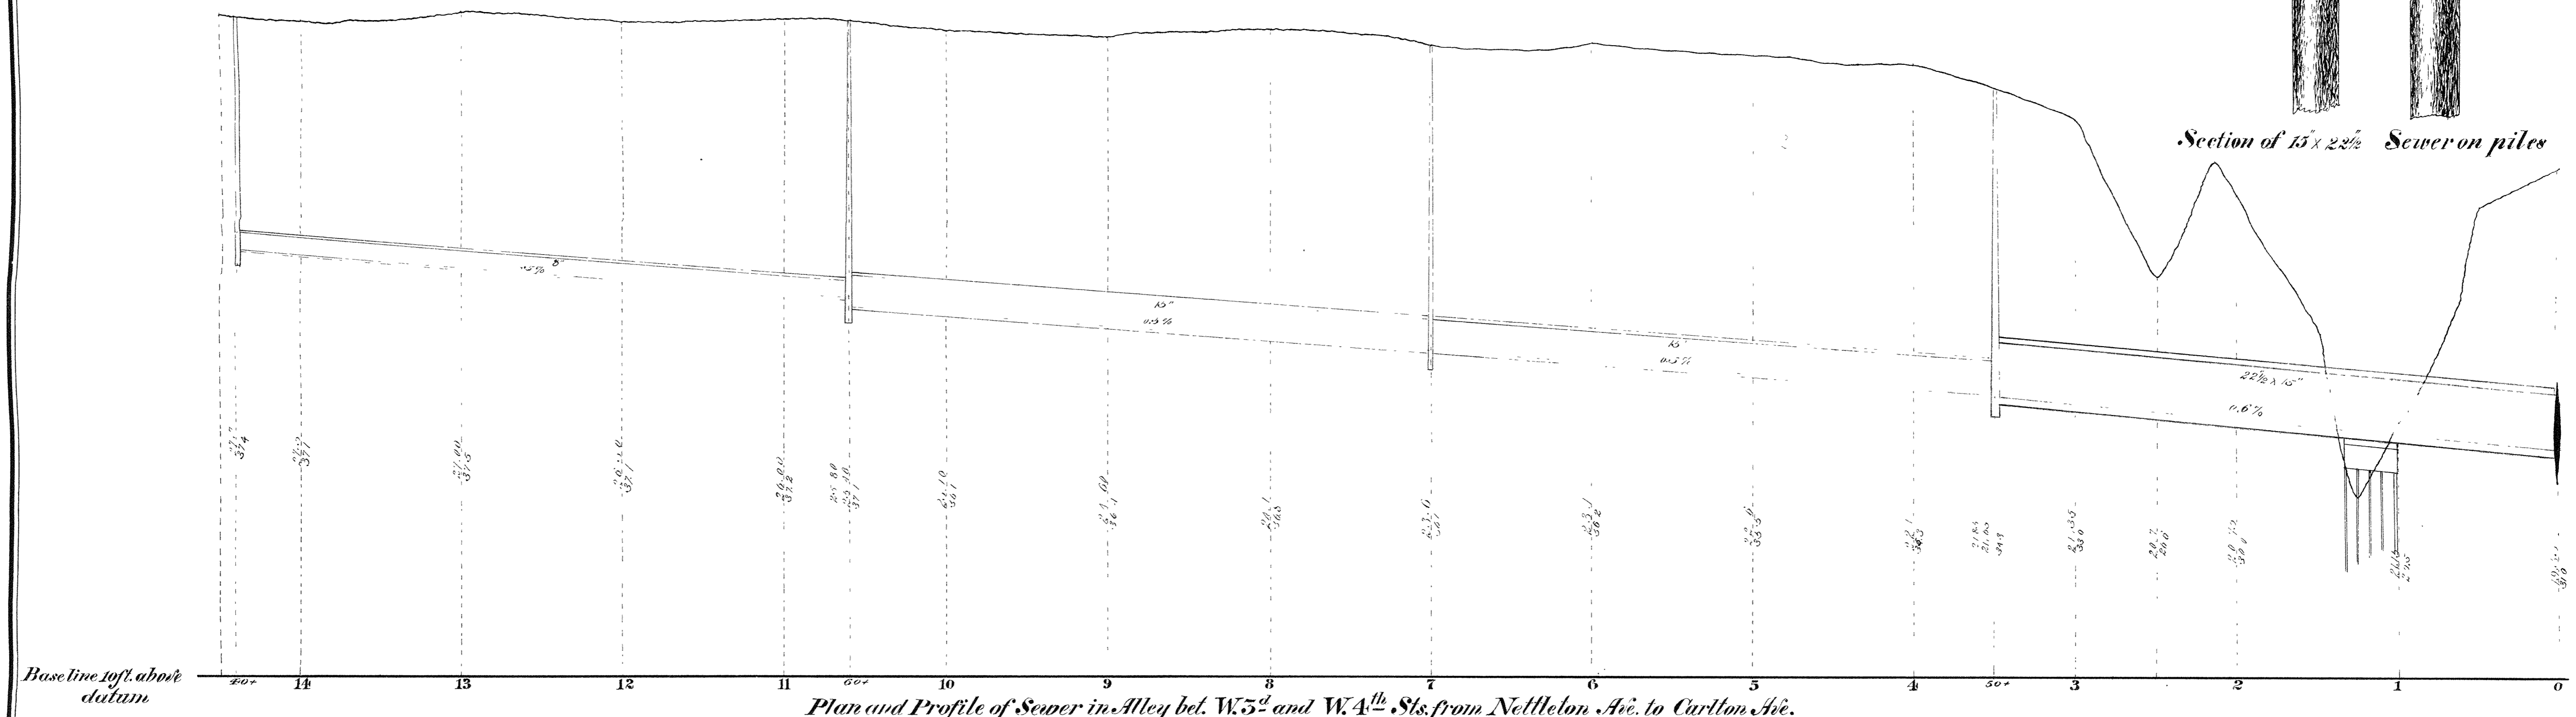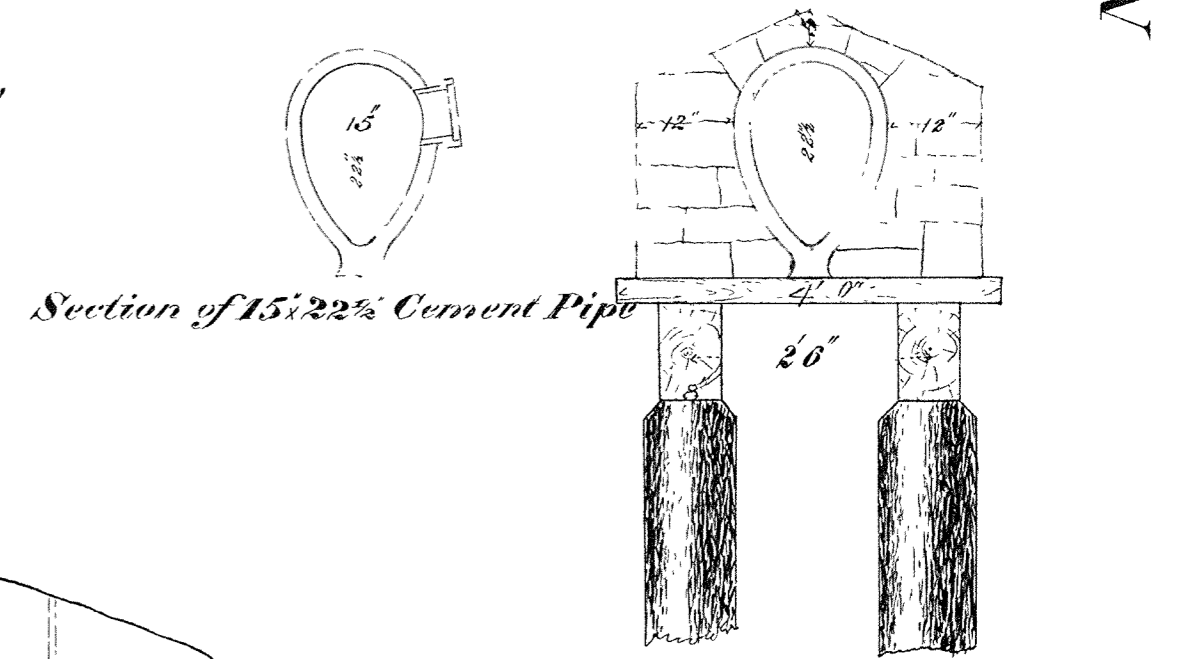

Plan and Profile of Sewer in Alley bet. W. 5th and W. 4th Sts. from Nettleton Ave. to Carlton Ave.