



MEASUREMENTS FOR HOUSE CONNECTIONS AT POINTS MIDWAY BETWEEN HOLES

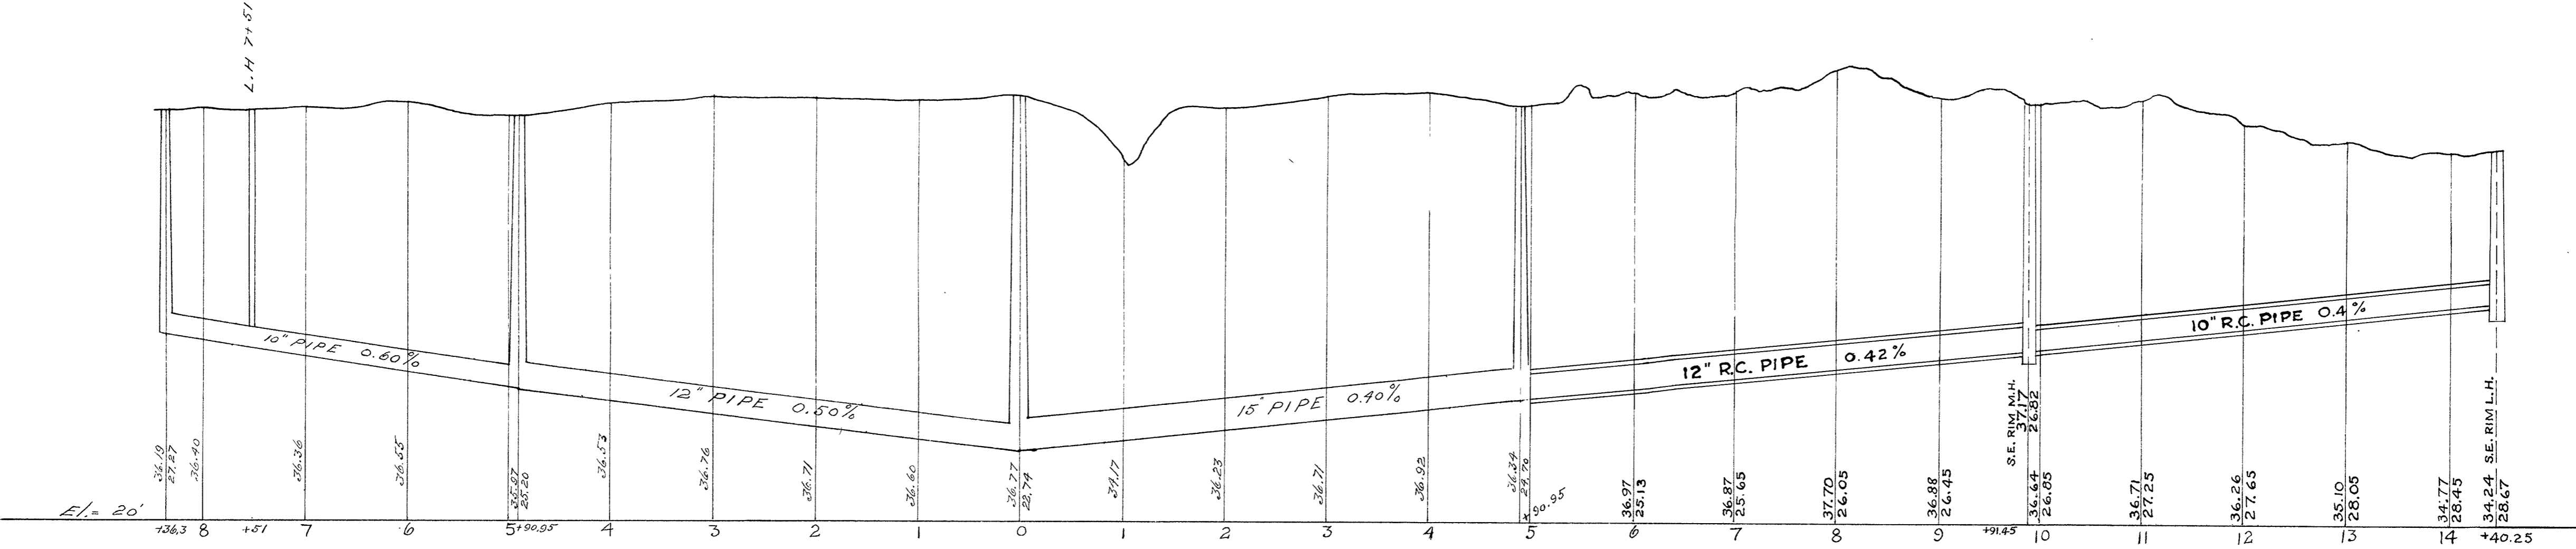

PLAN AND PROFILE OF SEWER IN ALLEY BETWEEN E. 2ND & 3RD STS. FROM RAILROAD AVE. TO 45TH AVE. E.

Horizontal Scale 1 inch = 100ft
 Vertical Scale 1 inch = 4ft.
 CONTRACT No 1555.
 Contract let June 22nd, 1917.
 Contract completed March 1st, 1918.
 S.A. Riches & Son. Contractors.
 E. M. Steffenson Inspector.
 E. B. Banks City Engineer.
 RICHES CEMENT PIPE USED.

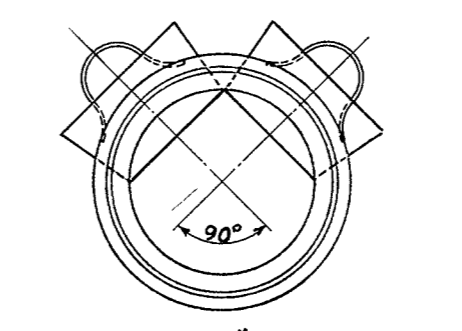

SECTION 12" R.C. PIPE

CITY OF SUPERIOR
 SEWER PLAN

HORIZONTAL SCALE: 1" = 100'
 VERTICAL SCALE: 1" = 4'

JOB STARTED JAN. 2, 1937
 JOB COMPLETED MAR. 15, 1937
 W.P.A. LABOR
 R.H.DANN INSPECTOR

L.W. PELESKE CITY ENGINEER

7-15