


STATE PROJECT NUMBER	SHEET NO.
8010-07-71	17
STORM SEWER/UTILITY PLAN	

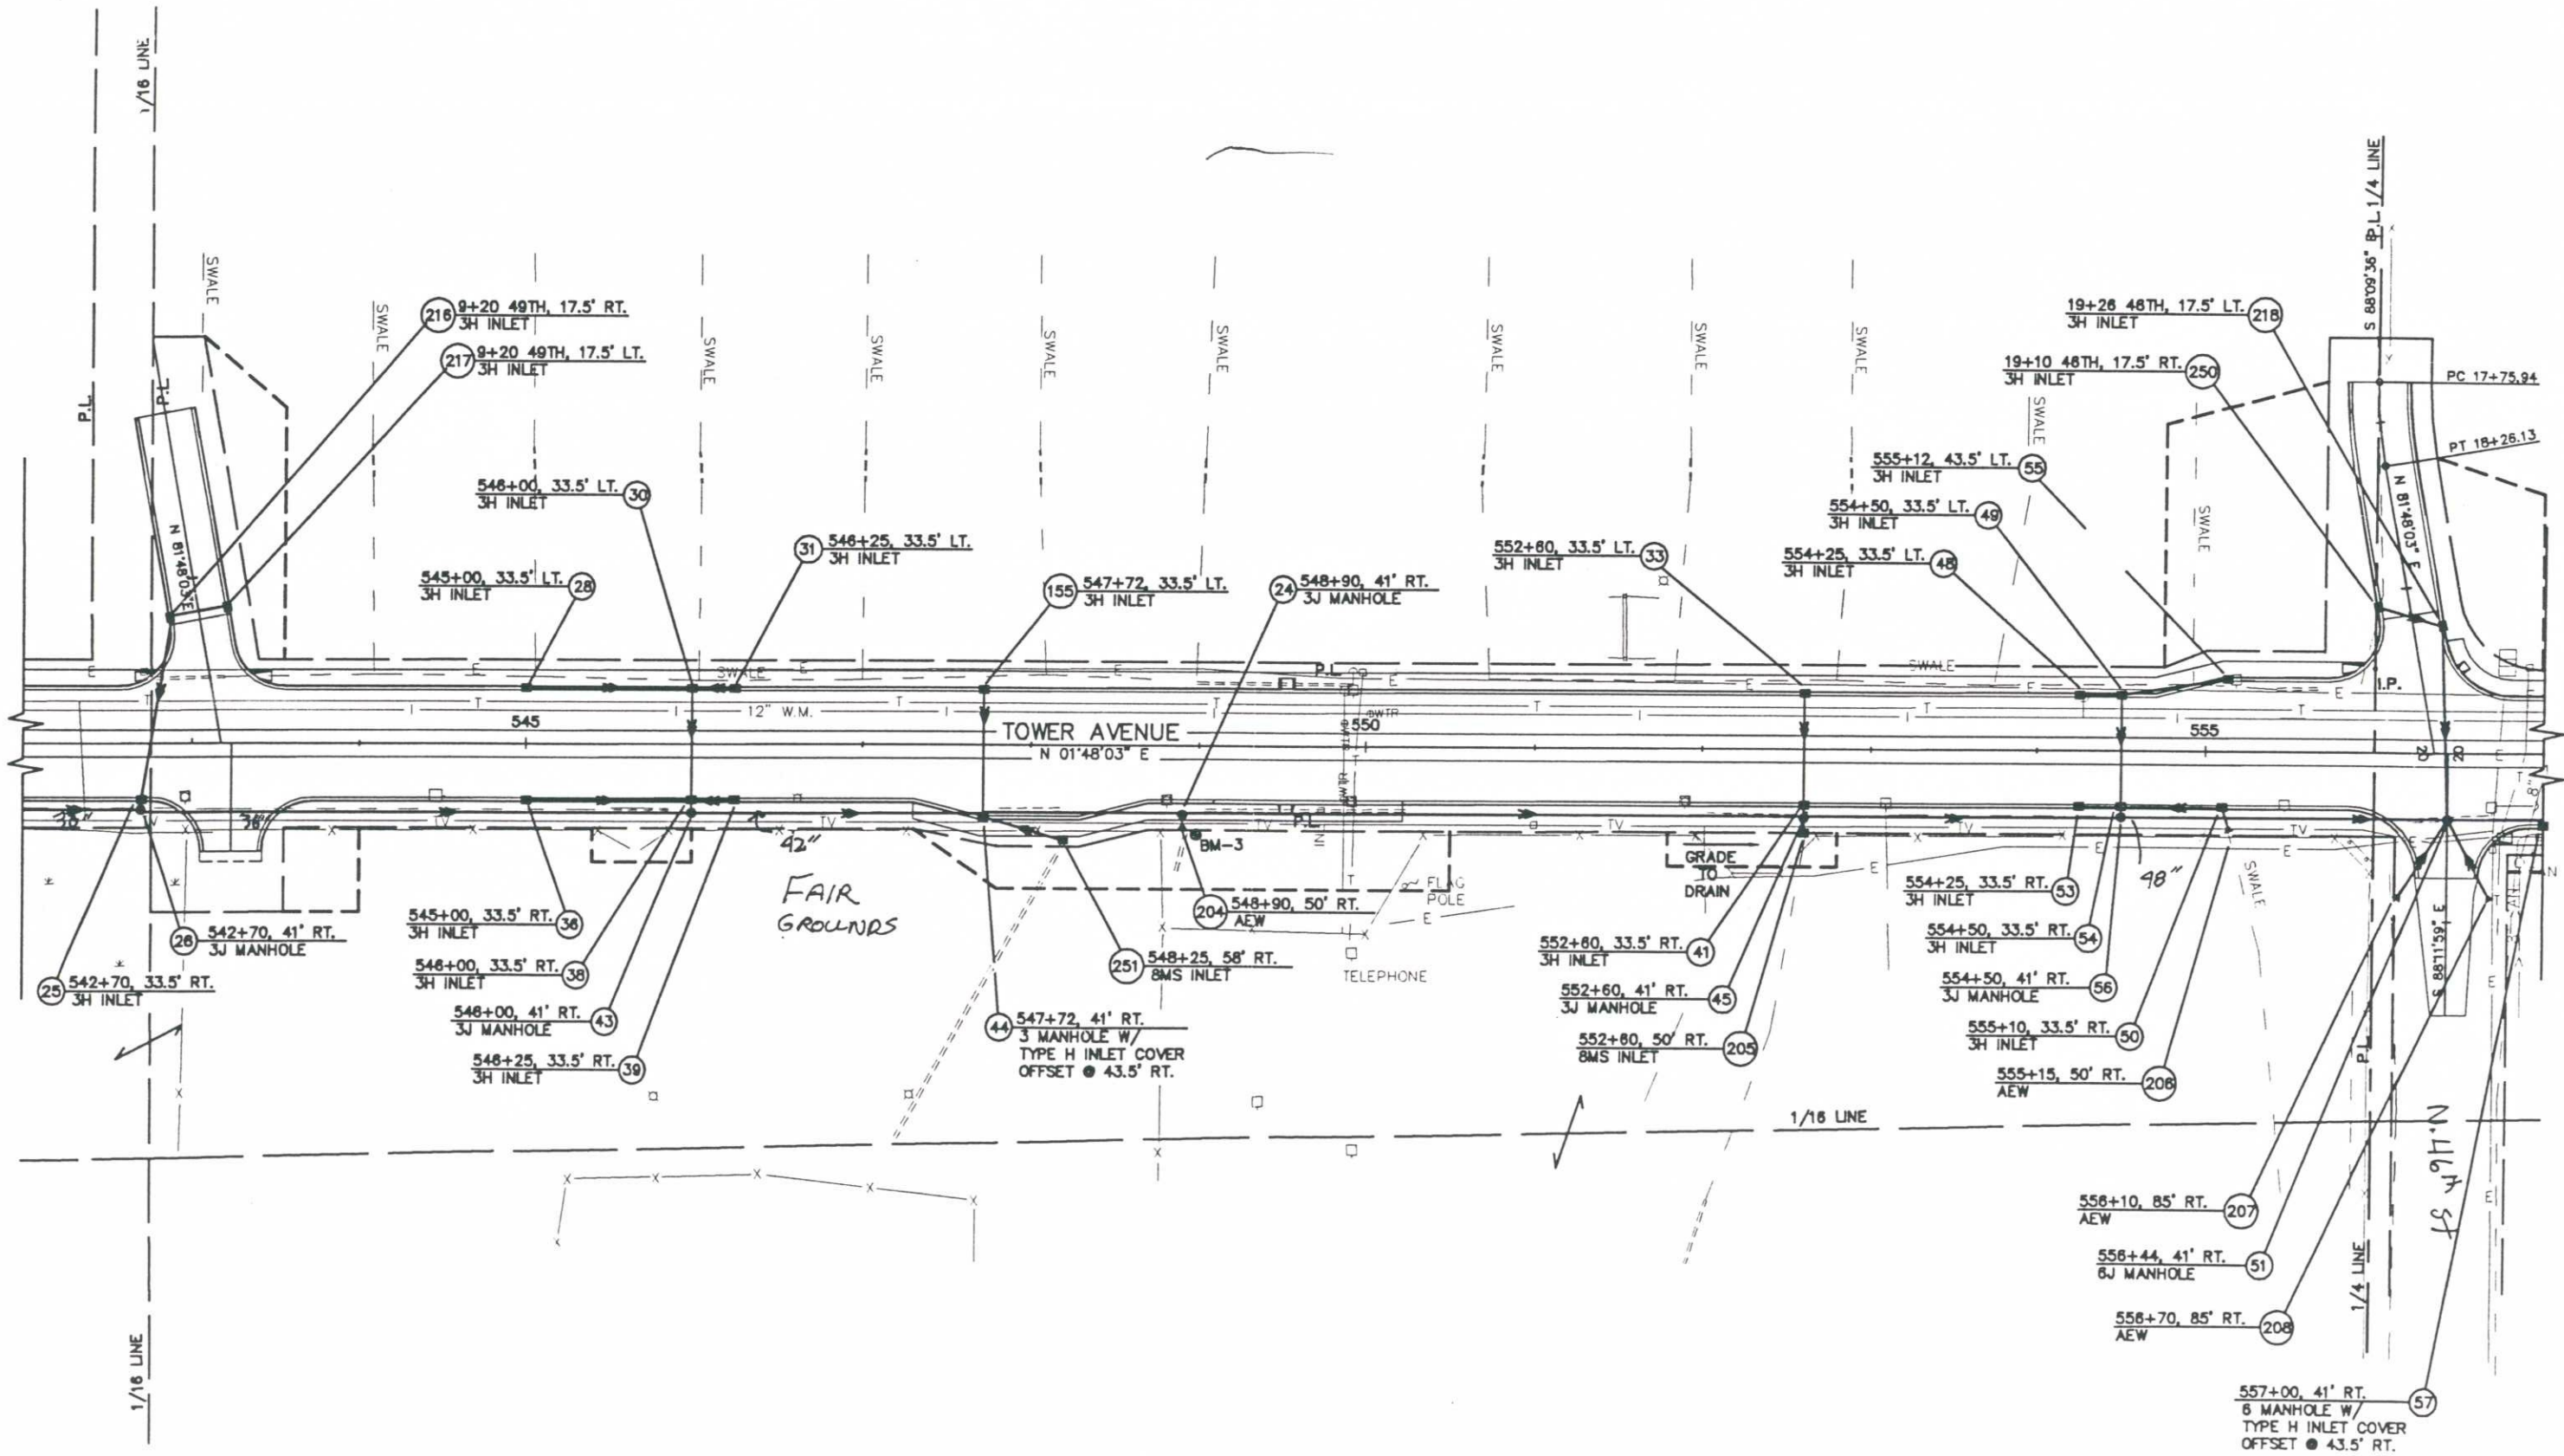

DRAWING BOARD 233000172