


STATE PROJECT NUMBER	SHEET NO.
8010-07-71	
STORM SEWER/UTILITY PLAN	

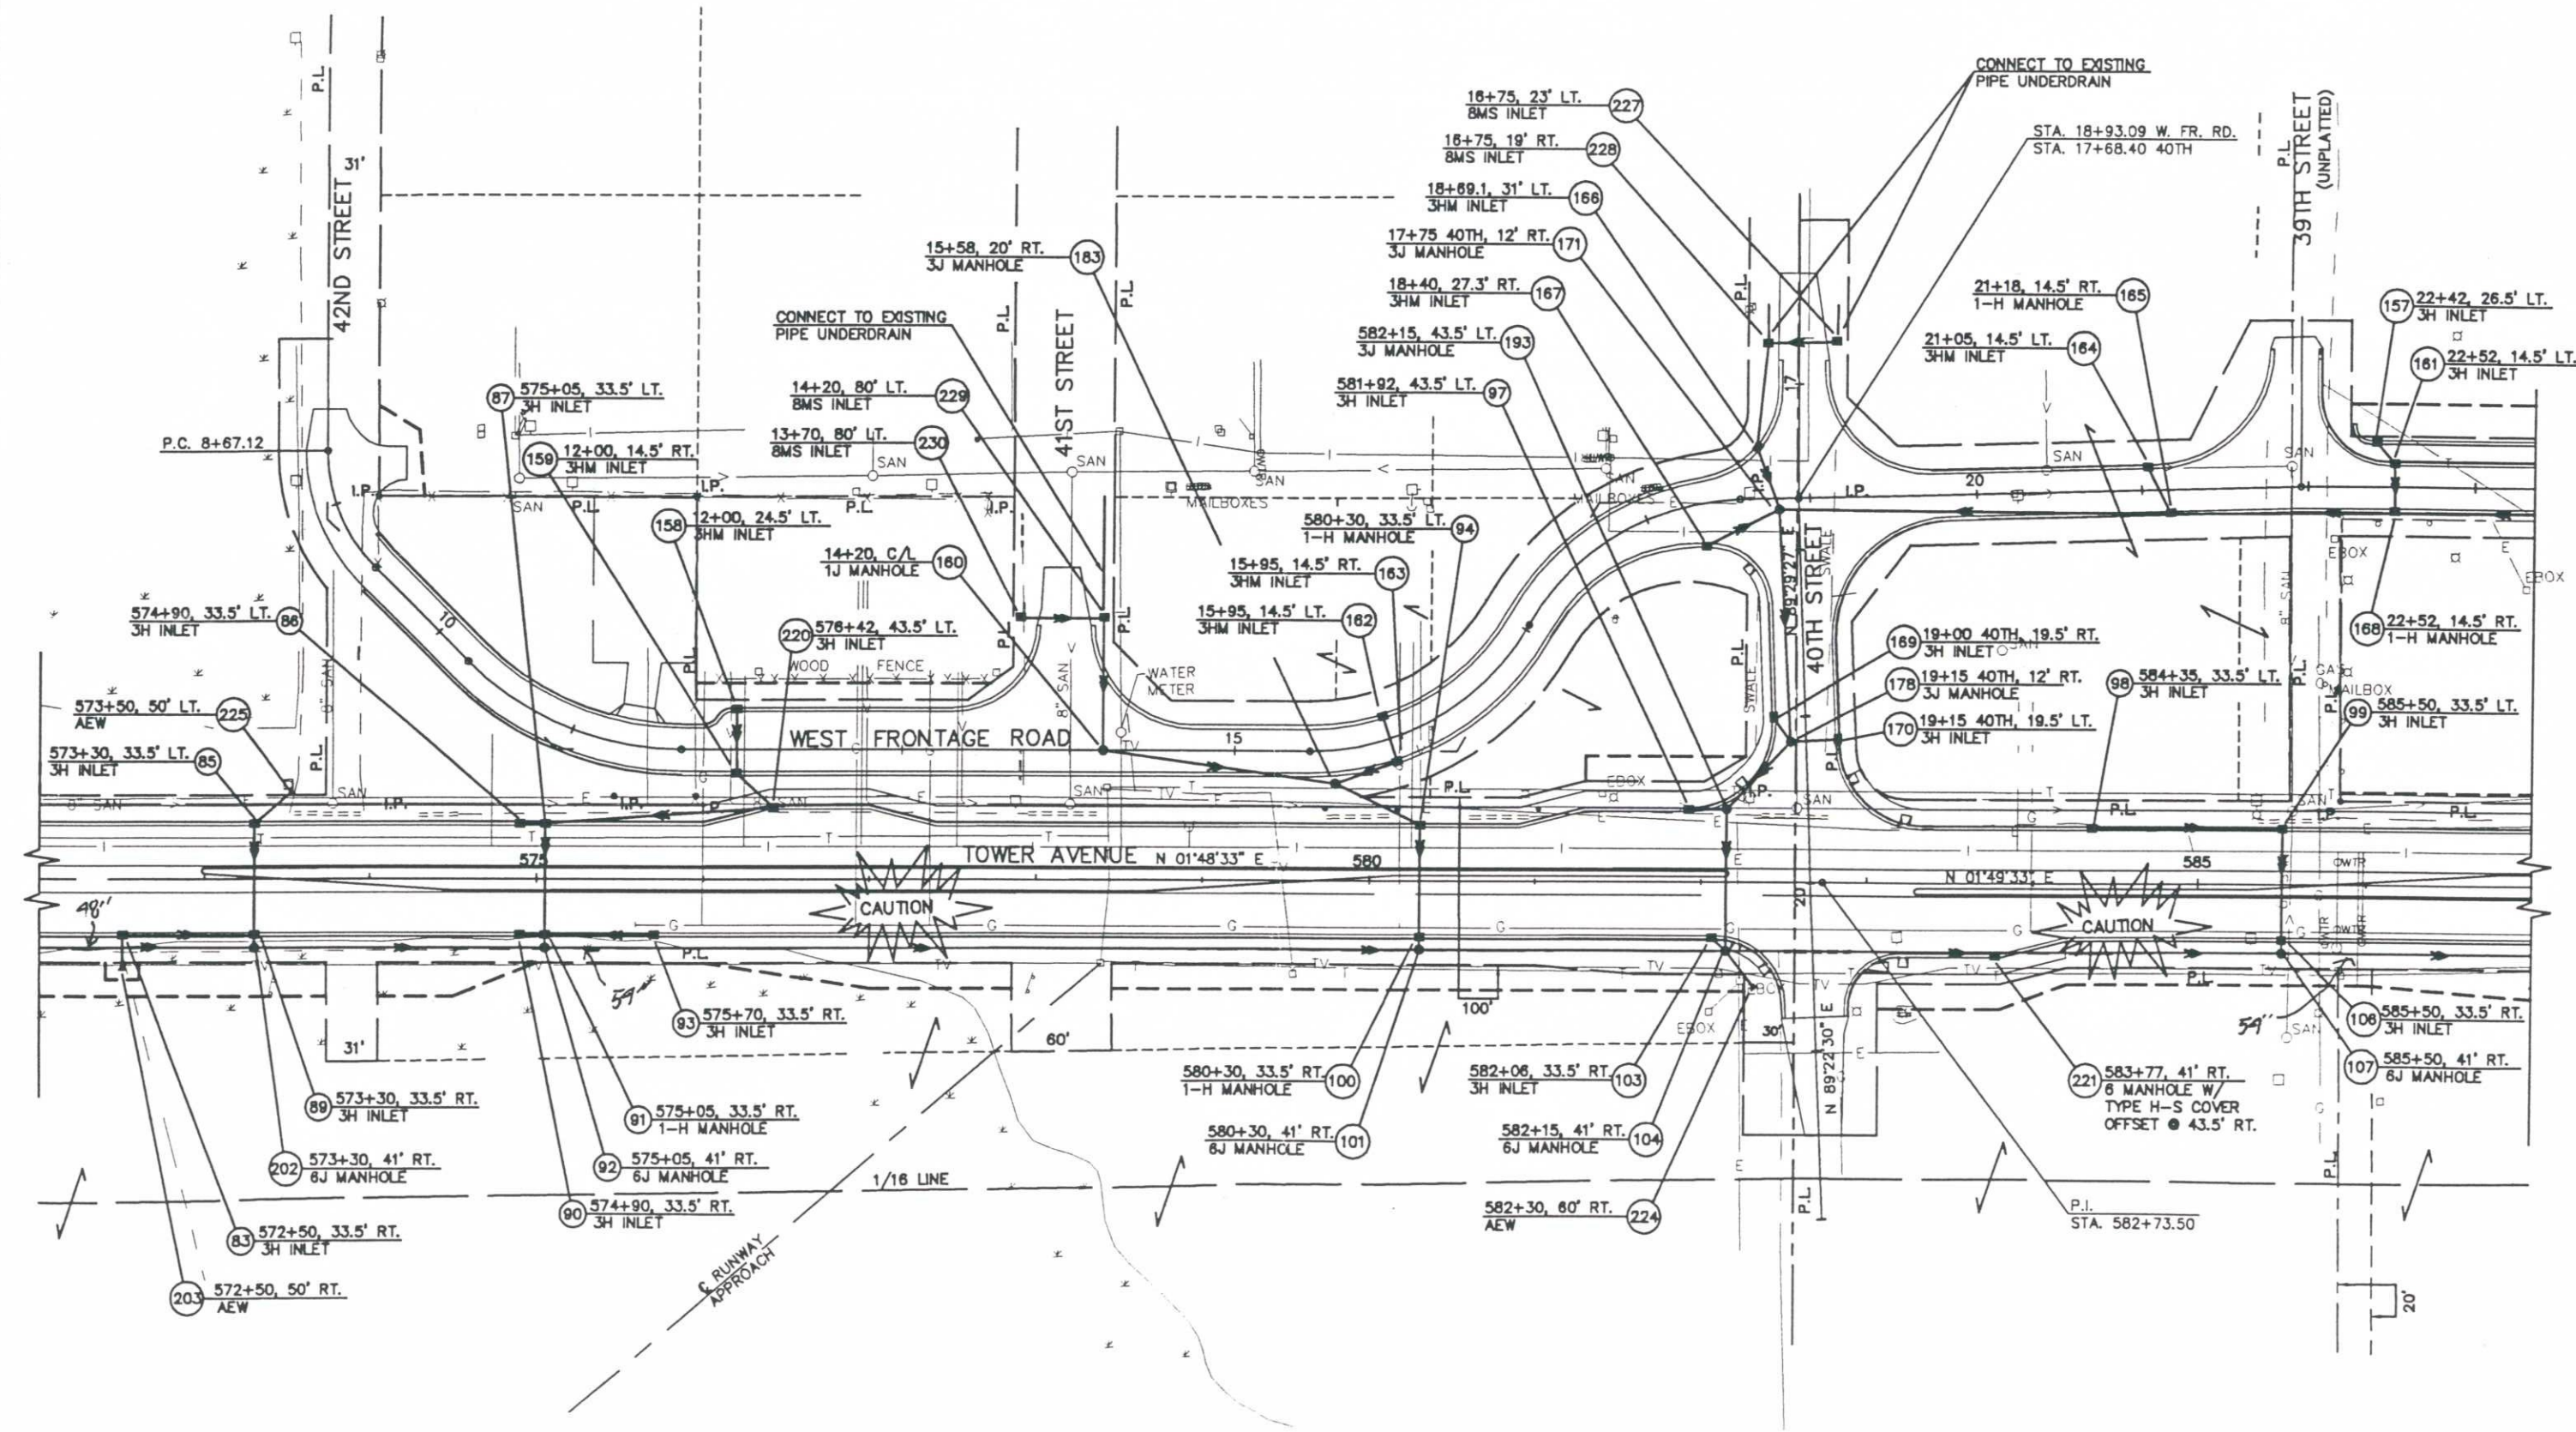

DRAWING NAME: 23300074  
LAYER: 071