
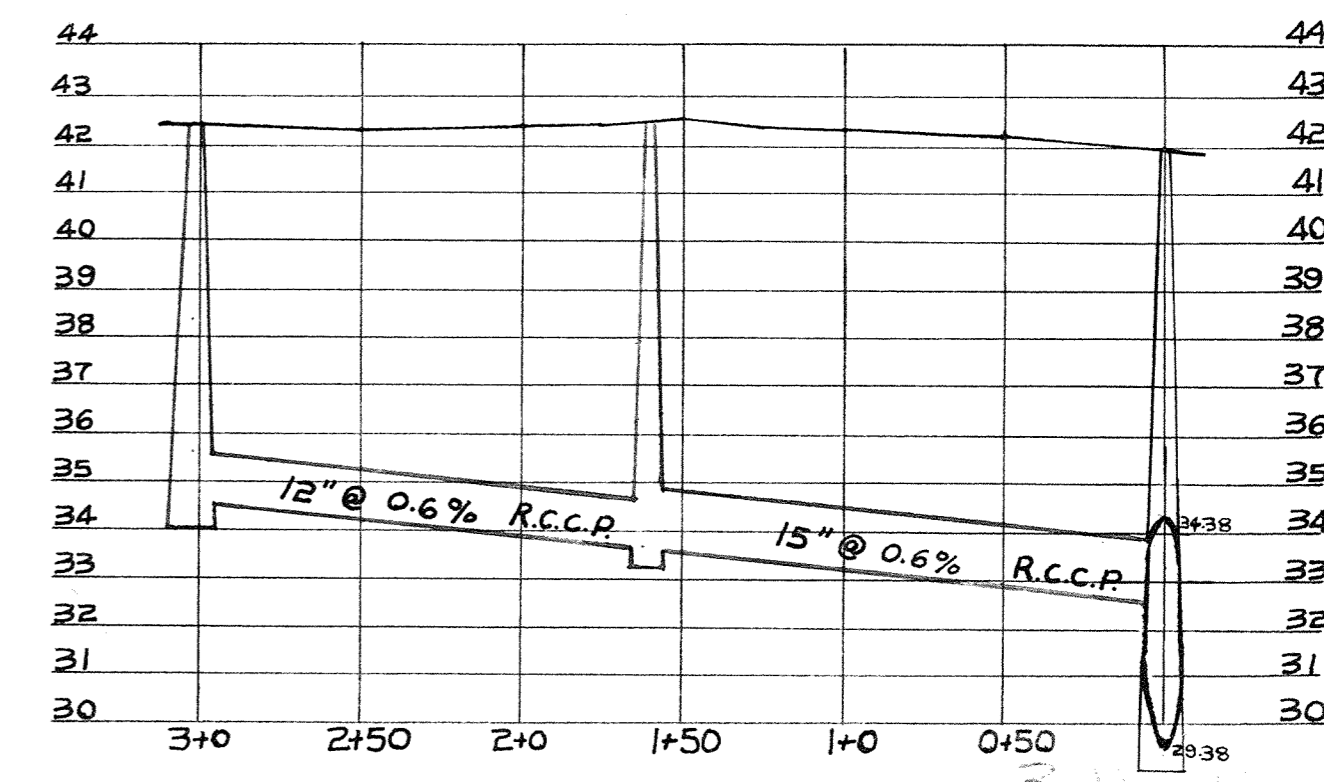


CITY OF SUPERIOR SEWER PLAN

CONTRACT 1618
CONTRACT LET SEPT. 15/20
" COMPLETED
S.A. RICHES CONTRACTOR
E.M. STEFFENSON INSPECTOR
E.B. BANKS CITY ENGINEER

PLAN AND PROFILE OF STORM SEWER

JOB COMPLETED SEP. 1955
CITY ENGINEER E.W. BERG
HORIZONTAL SCALE 1" = 60'
VERTICAL SCALE 1" = 4'

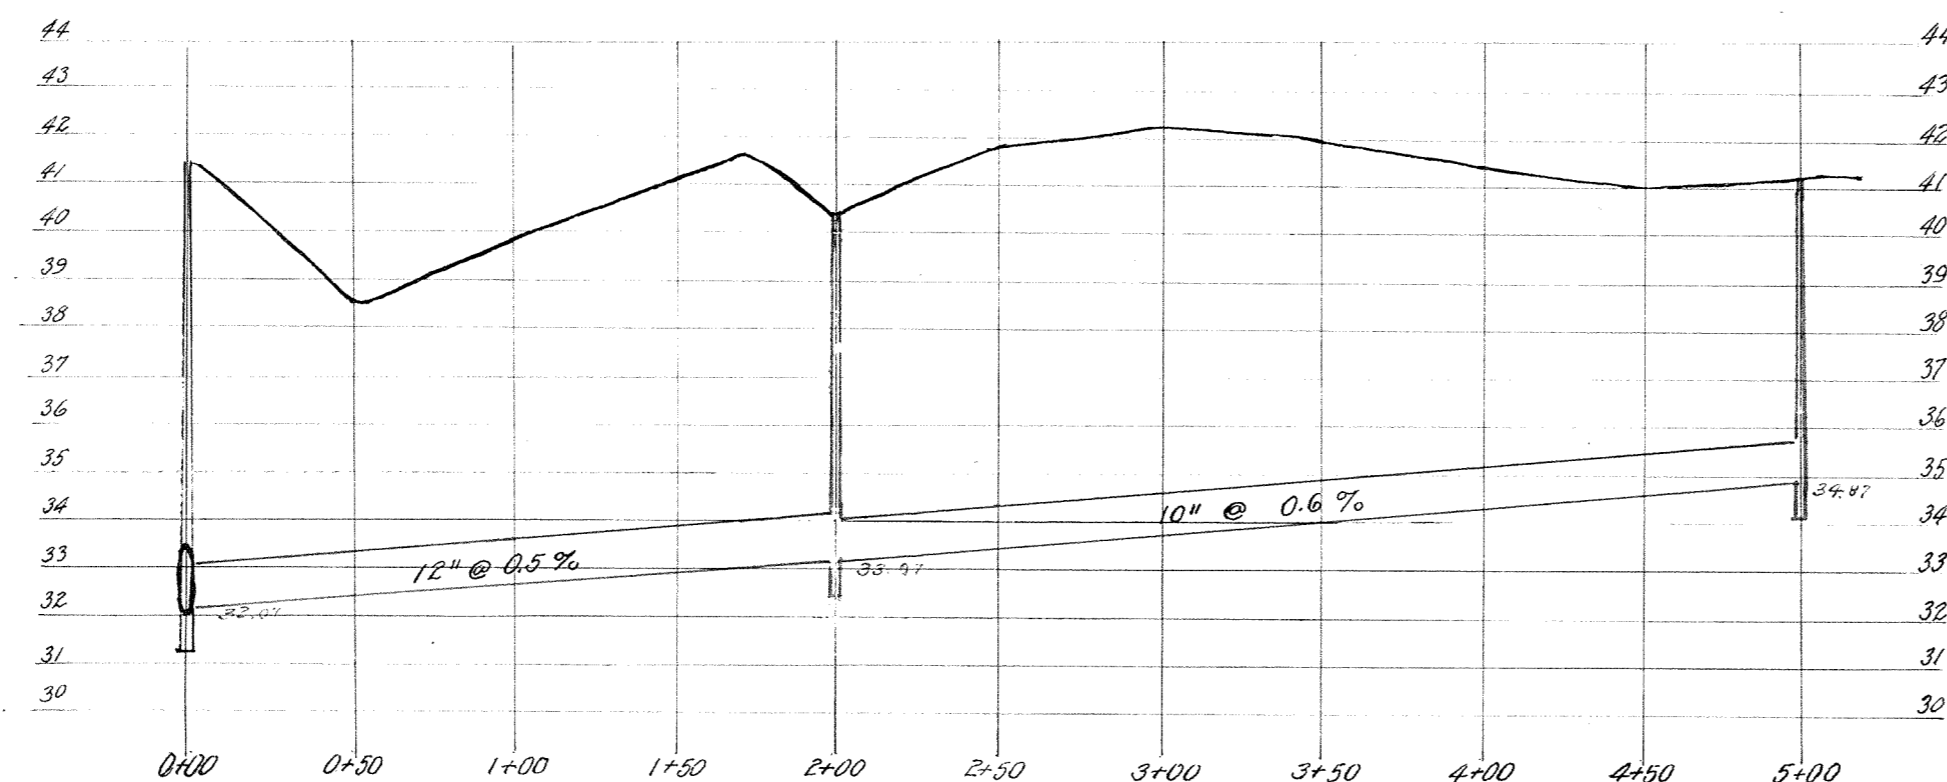

(CITY DATUM)