

**12' X 16' STANDARD HUT**  
**RACK LAYOUT PLAN**

SHEET #:  
**TYP**  
1 OF 1

| REVISIONS |             |
|-----------|-------------|
| △ DATE    | DESCRIPTION |
|           |             |
|           |             |
|           |             |
|           |             |
|           |             |
|           |             |


TYPICAL FIBER HUT  
**RACKING**

CLIENT: PROJECT:  
© 2024 RUCON ENGINEERS, LLC  
 RUCON ENGINEERS, LLC IS THE AUTHOR OF THIS DESIGN. ALL RIGHTS ARE RESERVED BY RUCON ENGINEERS, LLC. NO PART OF THIS DESIGN MAY BE REPRODUCED OR TRANSMITTED IN ANY FORM OR BY ANY MEANS, ELECTRONIC OR MECHANICAL, WITHOUT PERMISSION IN WRITING FROM RUCON ENGINEERS, LLC.

**RUCON ENGINEERS**  
 609 W MAPLE ST  
 POCATELLO, ID 83201  
 www.RuConCE.com  
 Bus: (208) 479-6381

|              |                   |
|--------------|-------------------|
| DRN. BY: MF  | DATE: 07-29-2022  |
| DSN. BY: MF  | JOB NO.: RC 20-24 |
| APPD. BY: MF | SCALE: AS NOTED   |

PRELIMINARY:  
NOT FOR  
CONSTRUCTION

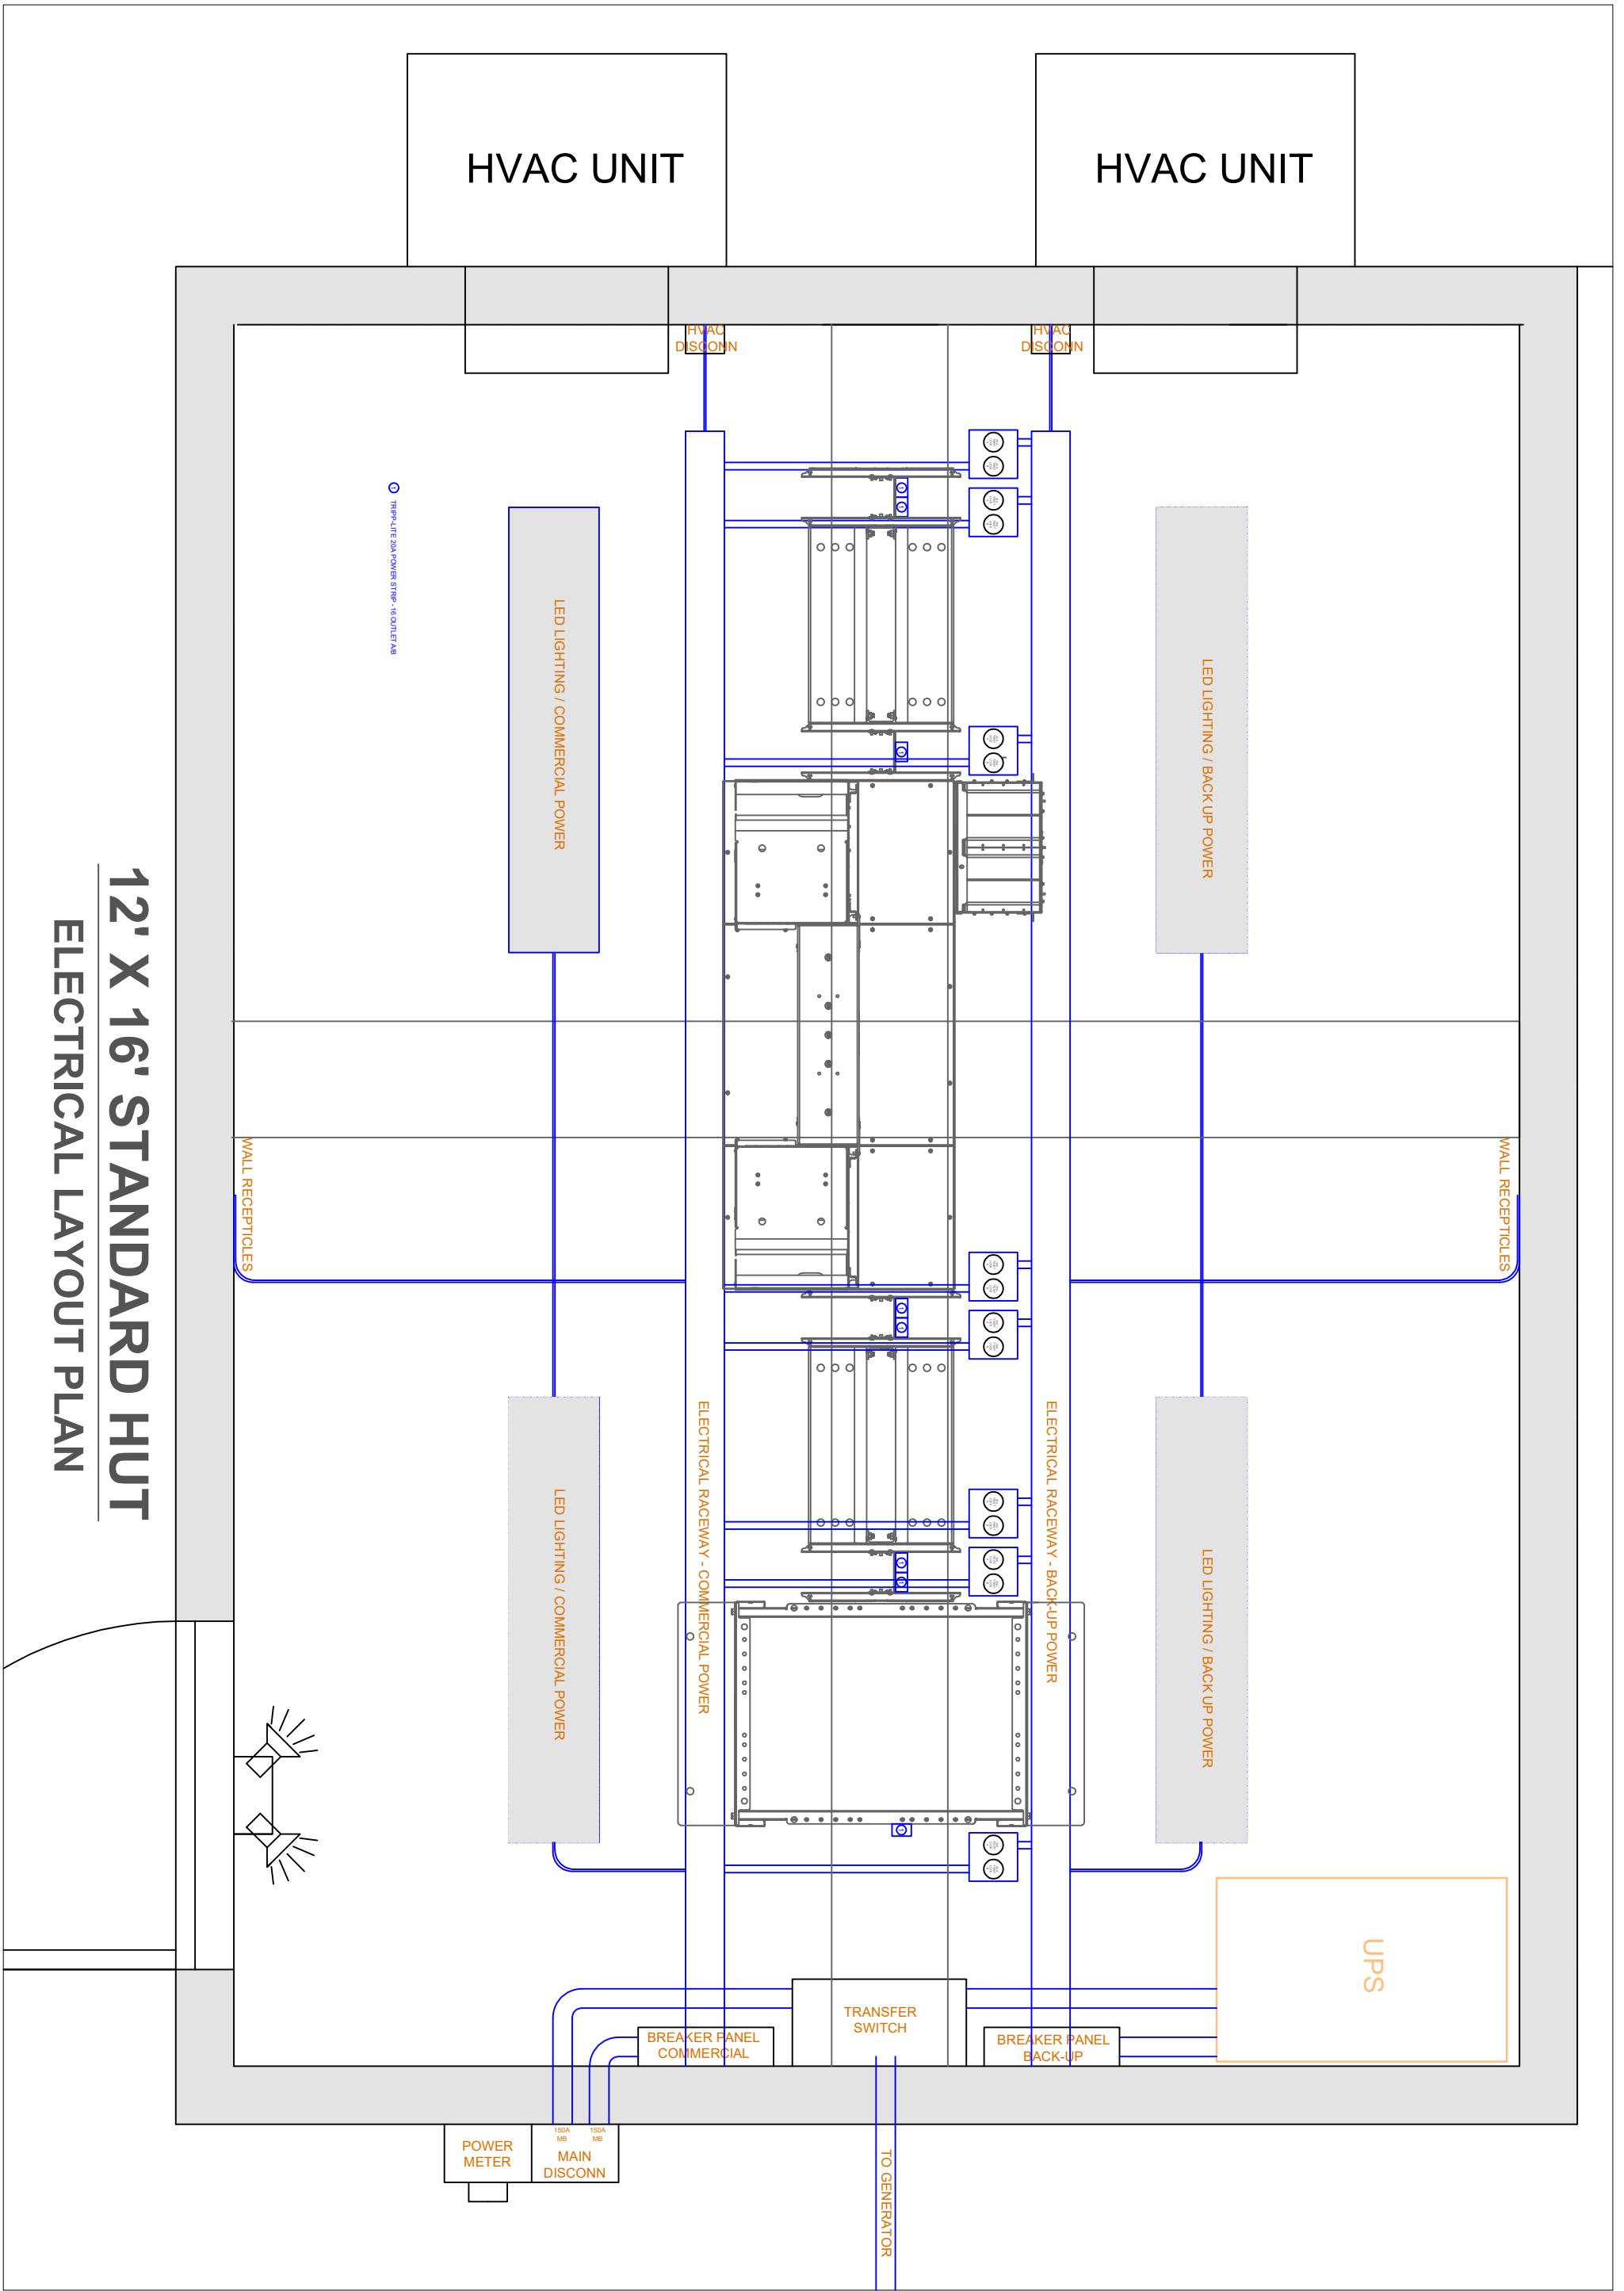

# 12' X 16' STANDARD HUT

## ELECTRICAL LAYOUT PLAN

SHEET #:  
**TYP**

1 OF 1

| REVISIONS |             |
|-----------|-------------|
| △ DATE    | DESCRIPTION |
|           |             |
|           |             |
|           |             |
|           |             |
|           |             |
|           |             |

CLIENT NAME

Drawing


CLIENT: PROJECT:

© 2016 RUCON ENGINEERS, LLC  
RUCON ENGINEERS, LLC IS THE AUTHOR OF THIS DRAWING. ANY AND ALL RIGHTS ARE RESERVED BY RUCON ENGINEERS, LLC. THIS DRAWING IS THE PROPERTY OF RUCON ENGINEERS, LLC AND IS NOT TO BE REPRODUCED OR TRANSMITTED IN ANY FORM OR BY ANY MEANS, ELECTRONIC OR MECHANICAL, INCLUDING PHOTOCOPYING, RECORDING, OR BY ANY INFORMATION STORAGE AND RETRIEVAL SYSTEM, WITHOUT THE WRITTEN PERMISSION OF RUCON ENGINEERS, LLC.

609 W MAPLE ST  
 POCATELLO, ID 83201  
 www.RuConCE.com  
 Bus: (208) 479-6381

|              |                   |
|--------------|-------------------|
| DRN. BY: RF  | DATE: 9-9-23      |
| DSN. BY: MF  | JOB NO.: RC 23-16 |
| APPD. BY: NF | SCALE: AS NOTED   |

PRELIMINARY:  
NOT FOR  
CONSTRUCTION

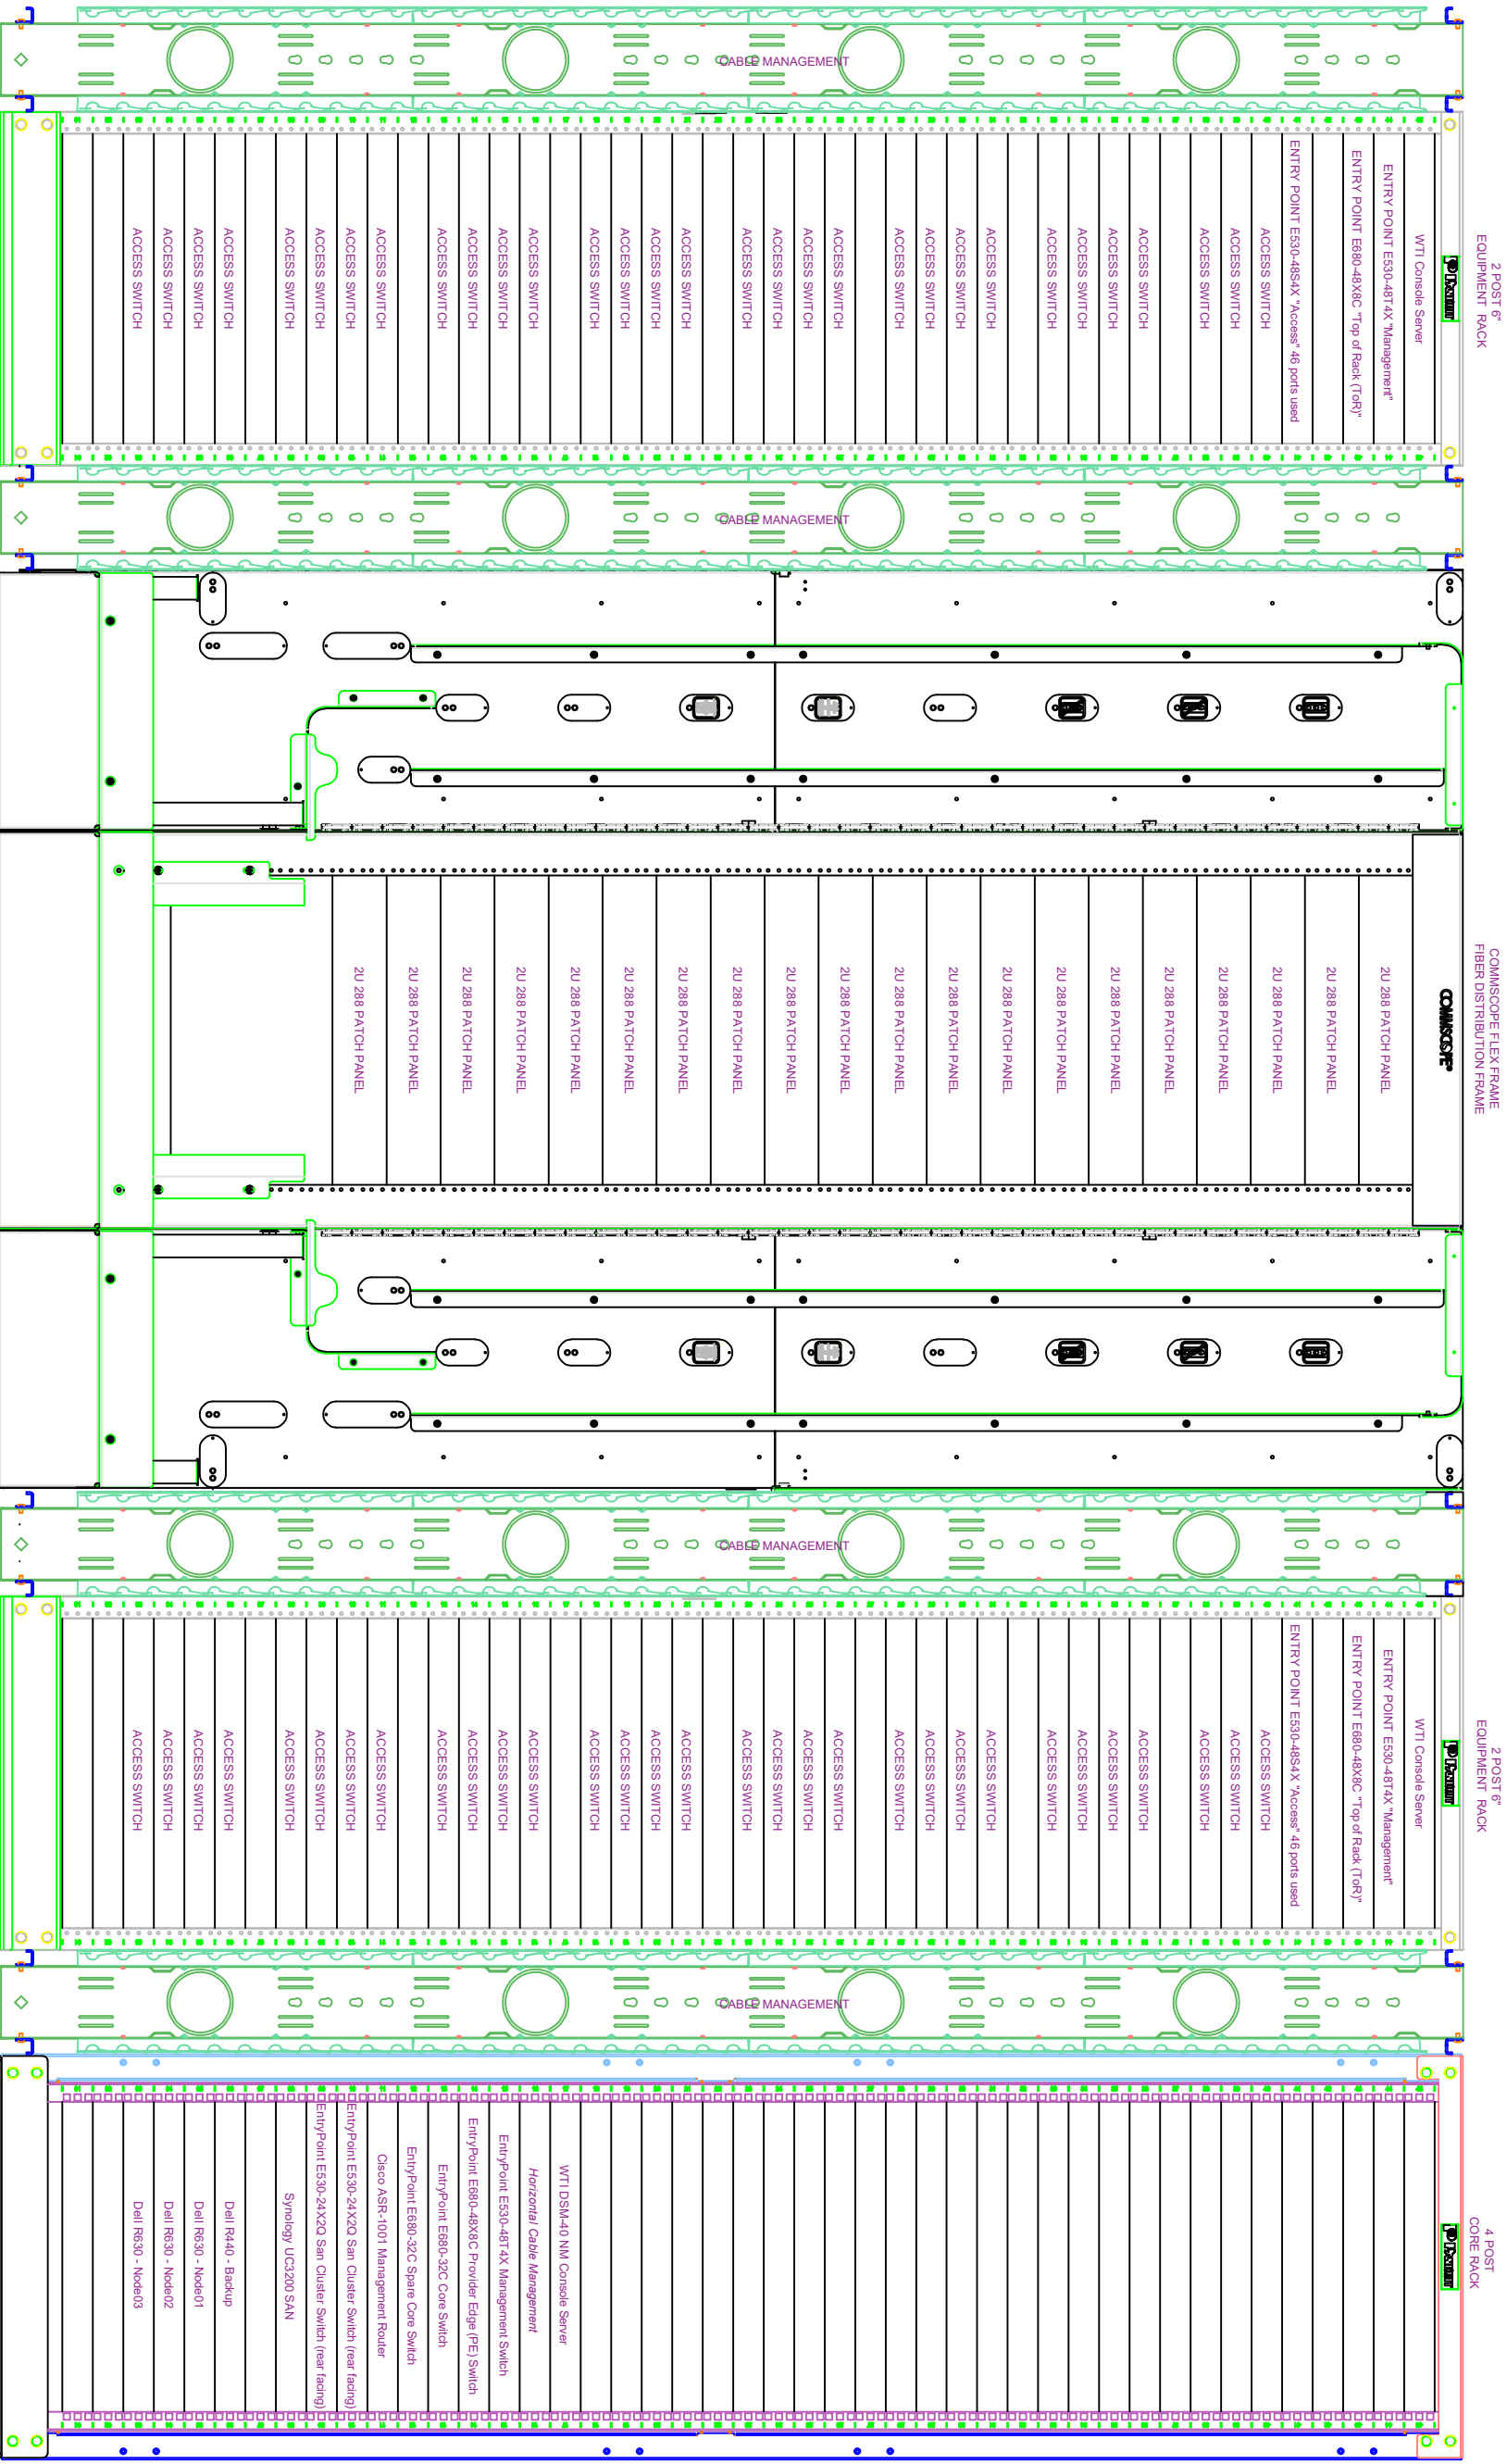

# TYPICAL EQUIPMENT RACK LINE-UP

## RACK LAYOUT PROFILE

| <b>TYP</b><br>SHEET #:<br>1 OF 1 | <b>REVISIONS</b><br><table border="1" style="width: 100%; border-collapse: collapse;"> <thead> <tr> <th style="width: 10%;">DATE</th> <th>DESCRIPTION</th> </tr> </thead> <tbody> <tr><td> </td><td> </td></tr> <tr><td> </td><td> </td></tr> <tr><td> </td><td> </td></tr> <tr><td> </td><td> </td></tr> <tr><td> </td><td> </td></tr> <tr><td> </td><td> </td></tr> <tr><td> </td><td> </td></tr> <tr><td> </td><td> </td></tr> <tr><td> </td><td> </td></tr> <tr><td> </td><td> </td></tr> </tbody> </table> | DATE | DESCRIPTION |  |  <b>TYPICAL FIBER HUT</b><br><br><b>RACKING PROFILE</b> | CLIENT: PROJECT:<br><br><small>© 2018 RUCON ENGINEERS, LLC<br/>         RUCON ENGINEERS, LLC IS AN AFFILIATE OF THE<br/>         RUCON GROUP OF COMPANIES. ALL RIGHTS RESERVED.<br/>         THIS DRAWING IS THE PROPERTY OF RUCON ENGINEERS, LLC.<br/>         IT IS TO BE USED ONLY FOR THE PROJECT AND SITE<br/>         SPECIFICALLY IDENTIFIED HEREON. ANY REUSE OR<br/>         MODIFICATION OF THIS DRAWING WITHOUT THE<br/>         WRITTEN PERMISSION OF RUCON ENGINEERS, LLC<br/>         IS STRICTLY PROHIBITED.</small> | <div style="display: flex; justify-content: space-between;"> <div> <b>RUCON</b><br/> <b>ENGINEERS</b> </div> <div style="font-size: small;">           609 W MAPLE ST<br/>           POCATELLO, ID 83201<br/>           www.RuConCE.com<br/>           Bus: (208) 479-6381         </div> </div> <table border="1" style="width: 100%; border-collapse: collapse; font-size: x-small;"> <tr> <td>DRN. BY: RF</td> <td>DATE: 09-29-23</td> </tr> <tr> <td>DSN. BY: MF</td> <td>JOB NO.: RC 23-16</td> </tr> <tr> <td>APPD. BY: NF</td> <td>SCALE: AS NOTED</td> </tr> </table> | DRN. BY: RF | DATE: 09-29-23 | DSN. BY: MF | JOB NO.: RC 23-16 | APPD. BY: NF | SCALE: AS NOTED | <b>PRELIMINARY:</b><br><b>NOT FOR</b><br><b>CONSTRUCTION</b> |
|----------------------------------|---|------|-------------|--|--|--|--|--|--|--|--|--|--|--|--|--|--|--|--|--|--|--|--|--|---|---|-------------|----------------|-------------|-------------------|--------------|-----------------|--|
| DATE                             | DESCRIPTION   |      |             |                                  |   |                                  |   |                                  |   |                                  |   |                                  |   |                                  |   |                                  |   |                                  |   |                                  |   |                                  |   | DRN. BY: RF                      | DATE: 09-29-23  |      |             | DSN. BY: MF                      | JOB NO.: RC 23-16   |      |             | APPD. BY: NF                     | SCALE: AS NOTED   |      |             